

LANDMARKS PRESERVATION COMMISSION
New York City AIDS Memorial

02/05/2013





0 50



NYC Parks

New York City AIDS Memorial
02/05/2013

Existing site plan
Scale: n/a




2




-  TRASH RECEPTACLE
-  LIGHT POLE
-  MOVEABLE TABLE & CHAIRS
-  WOOD BENCH
-  DRINKING FOUNTAIN
-  HORSE SHOE SURFACE MOUNT BIKE RACKS
-  PROPOSED TREE
-  EXISTING TREE




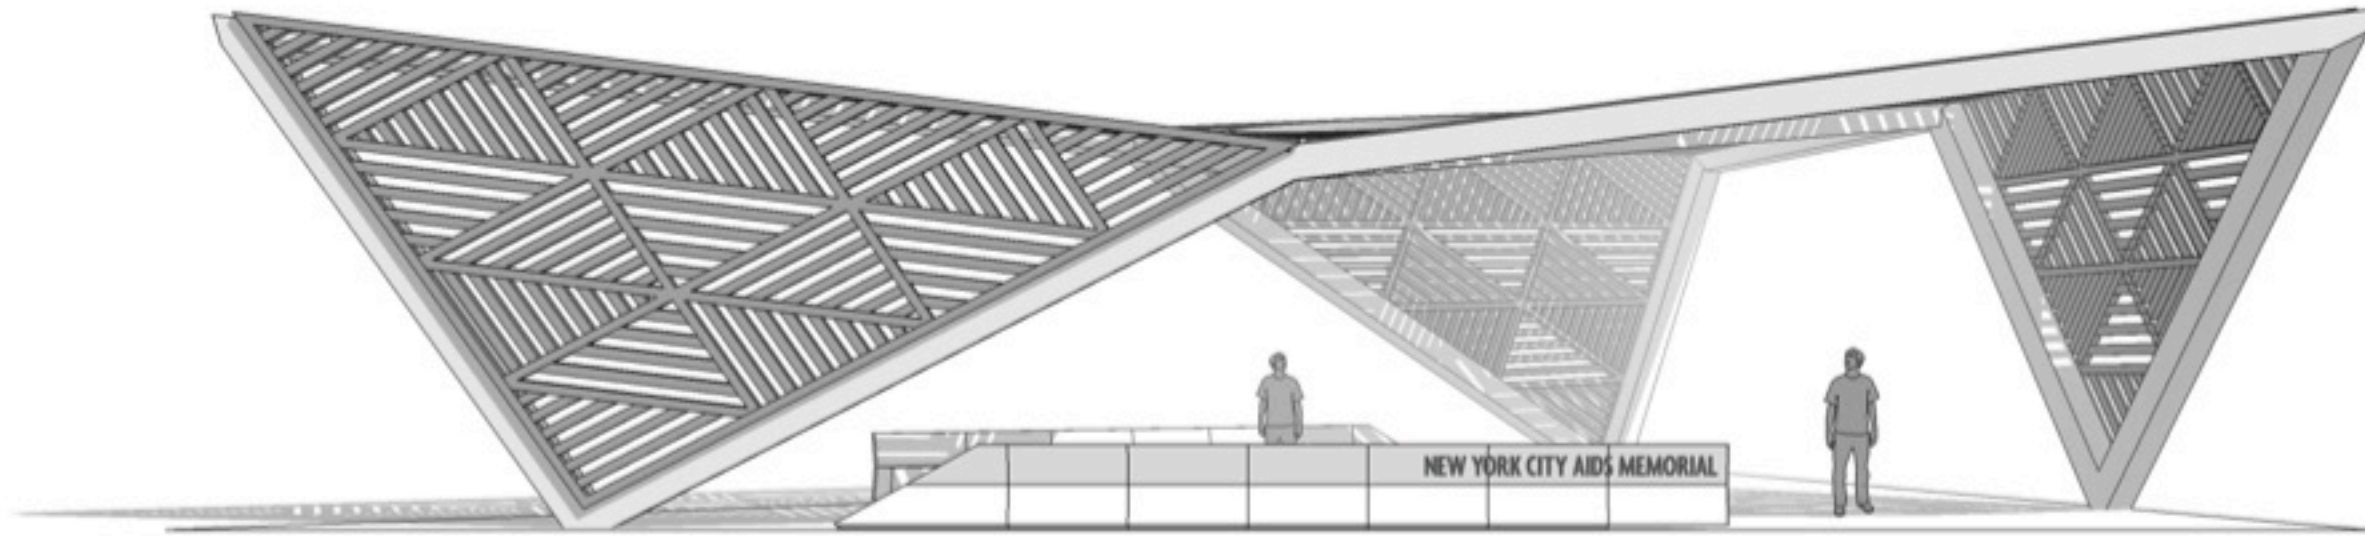


PREVIOUS structure elevation

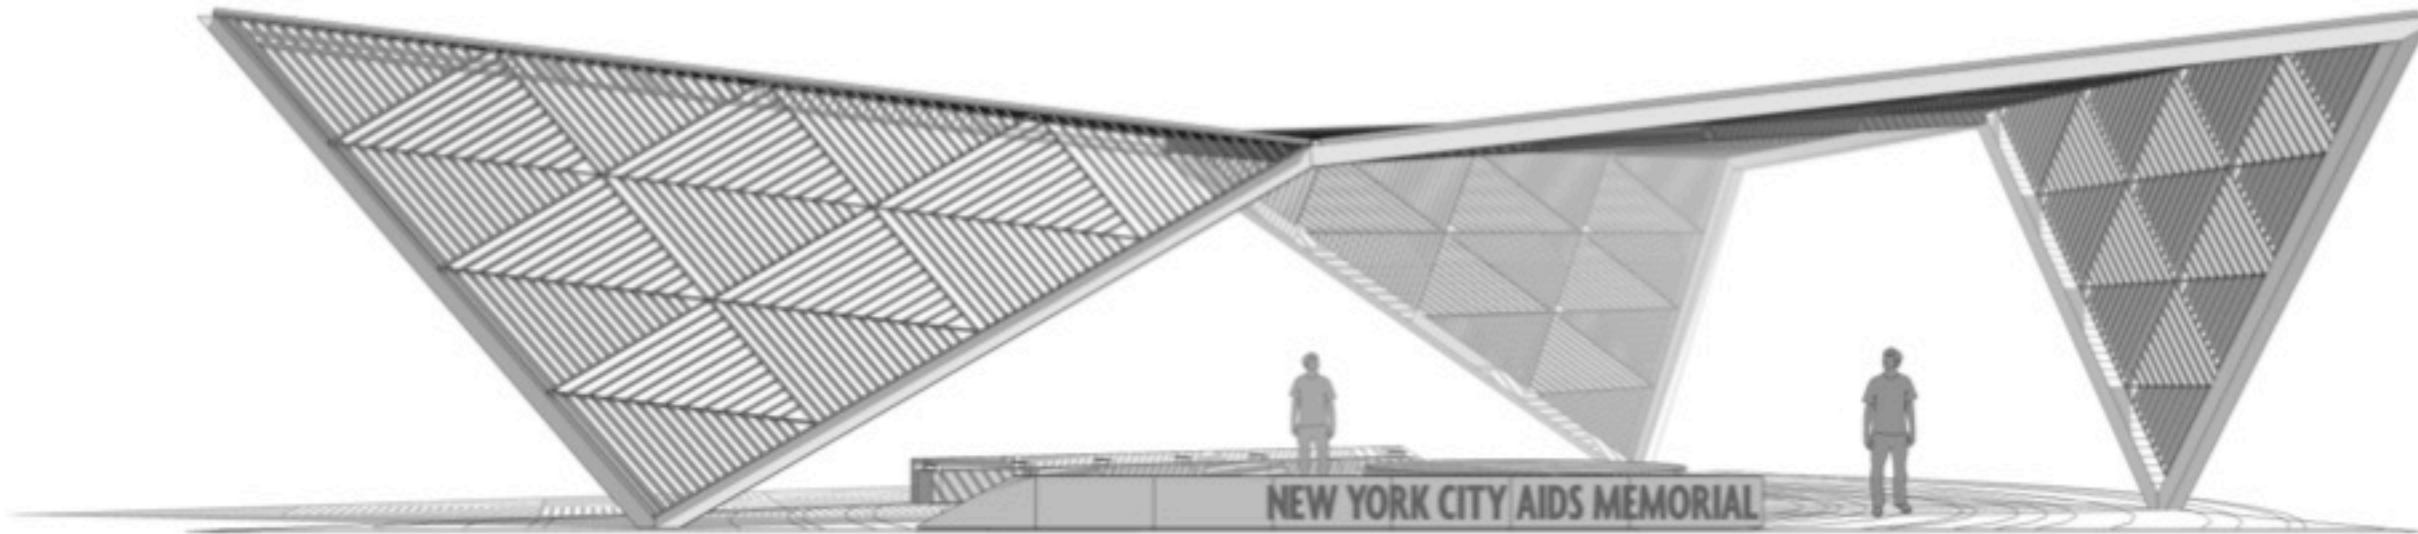


PROPOSED structure elevation
(lighter, less climbable, lower back benches)

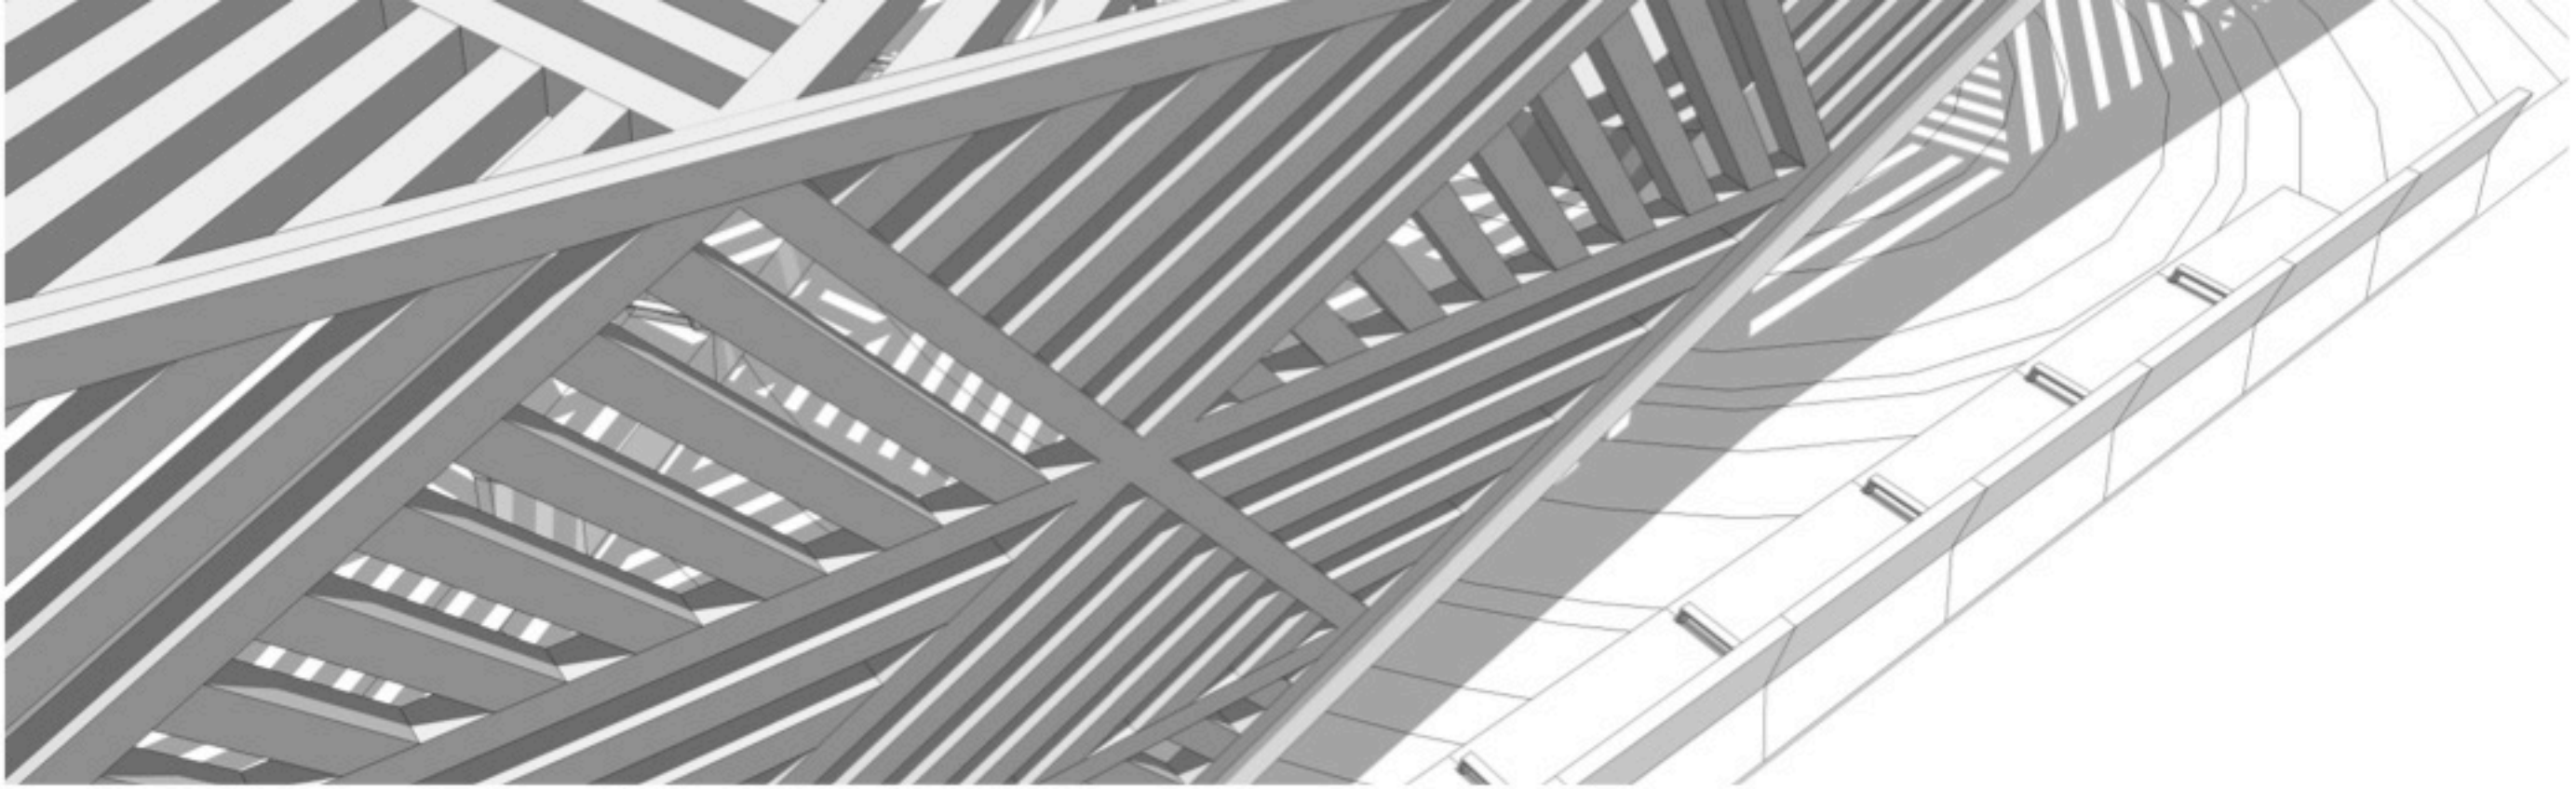



PREVIOUS structure elevation

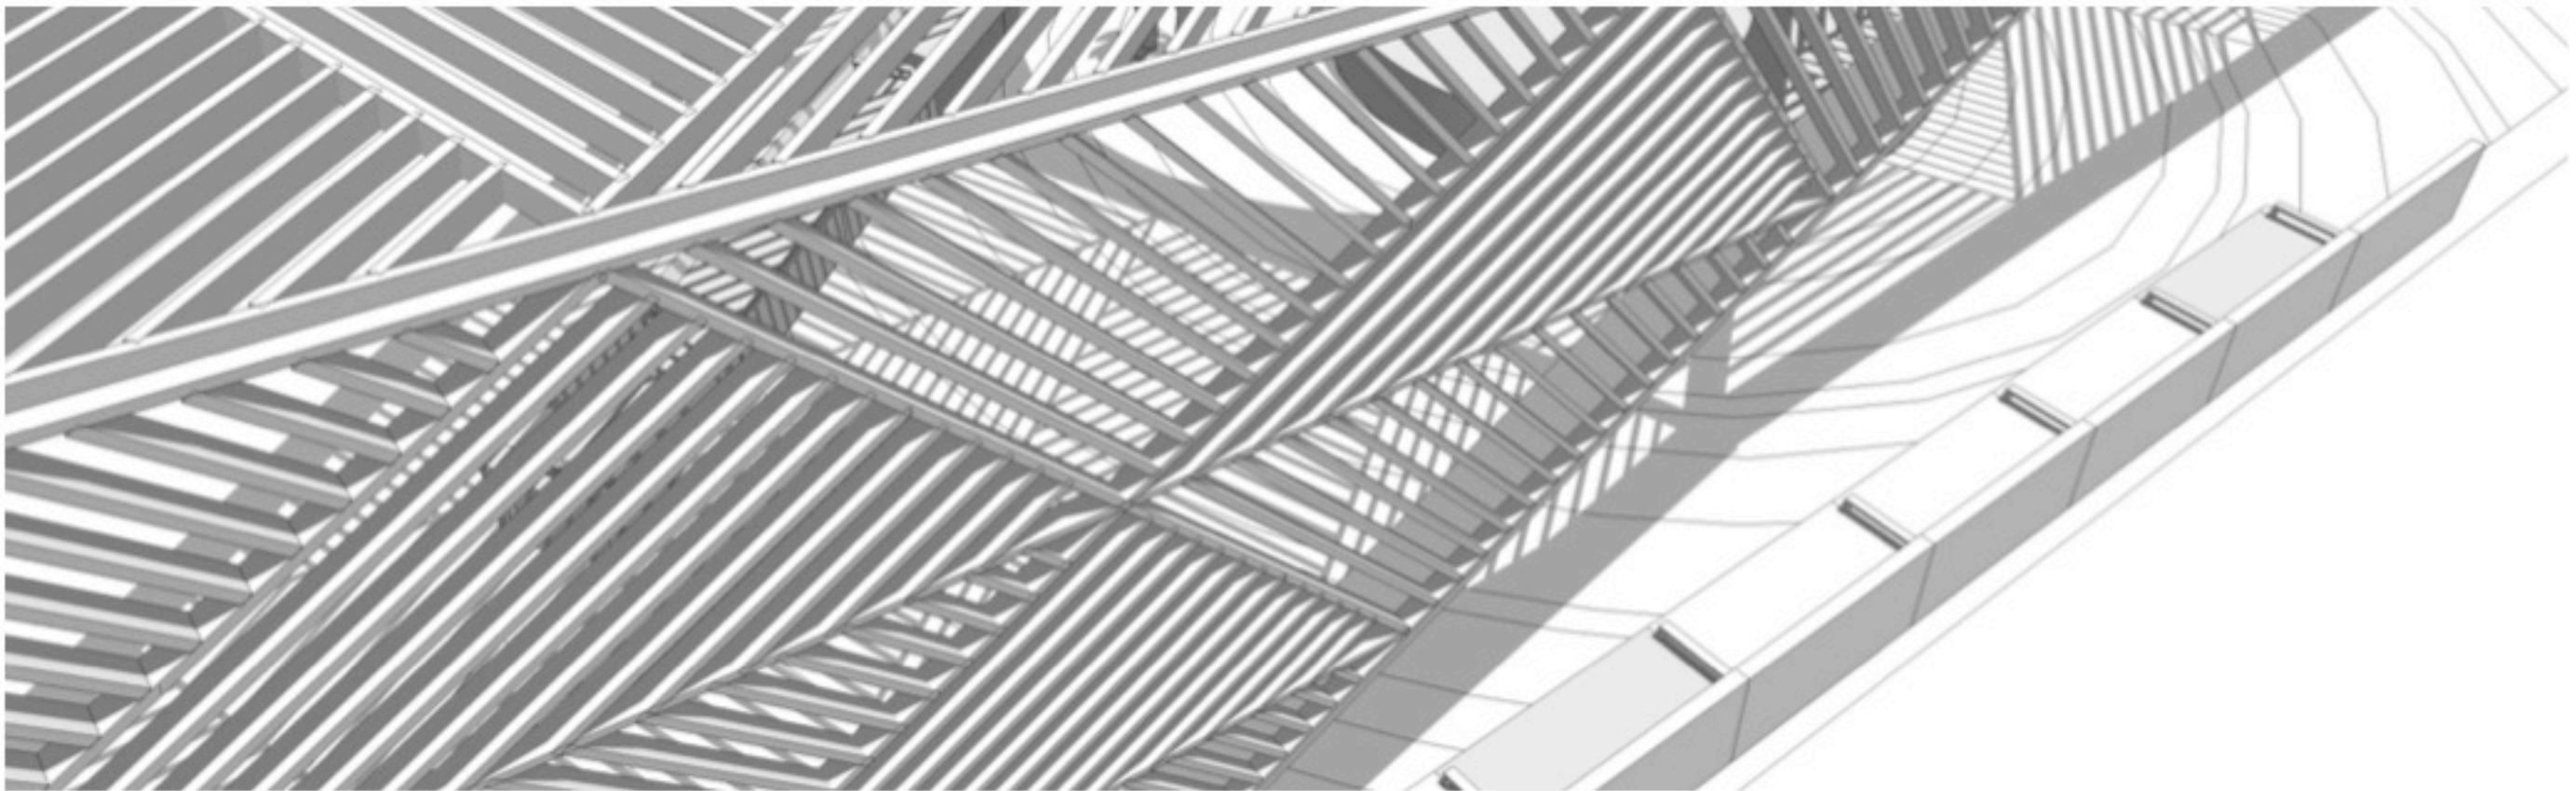


PROPOSED structure elevation
(lighter, less climbable, lower back benches)

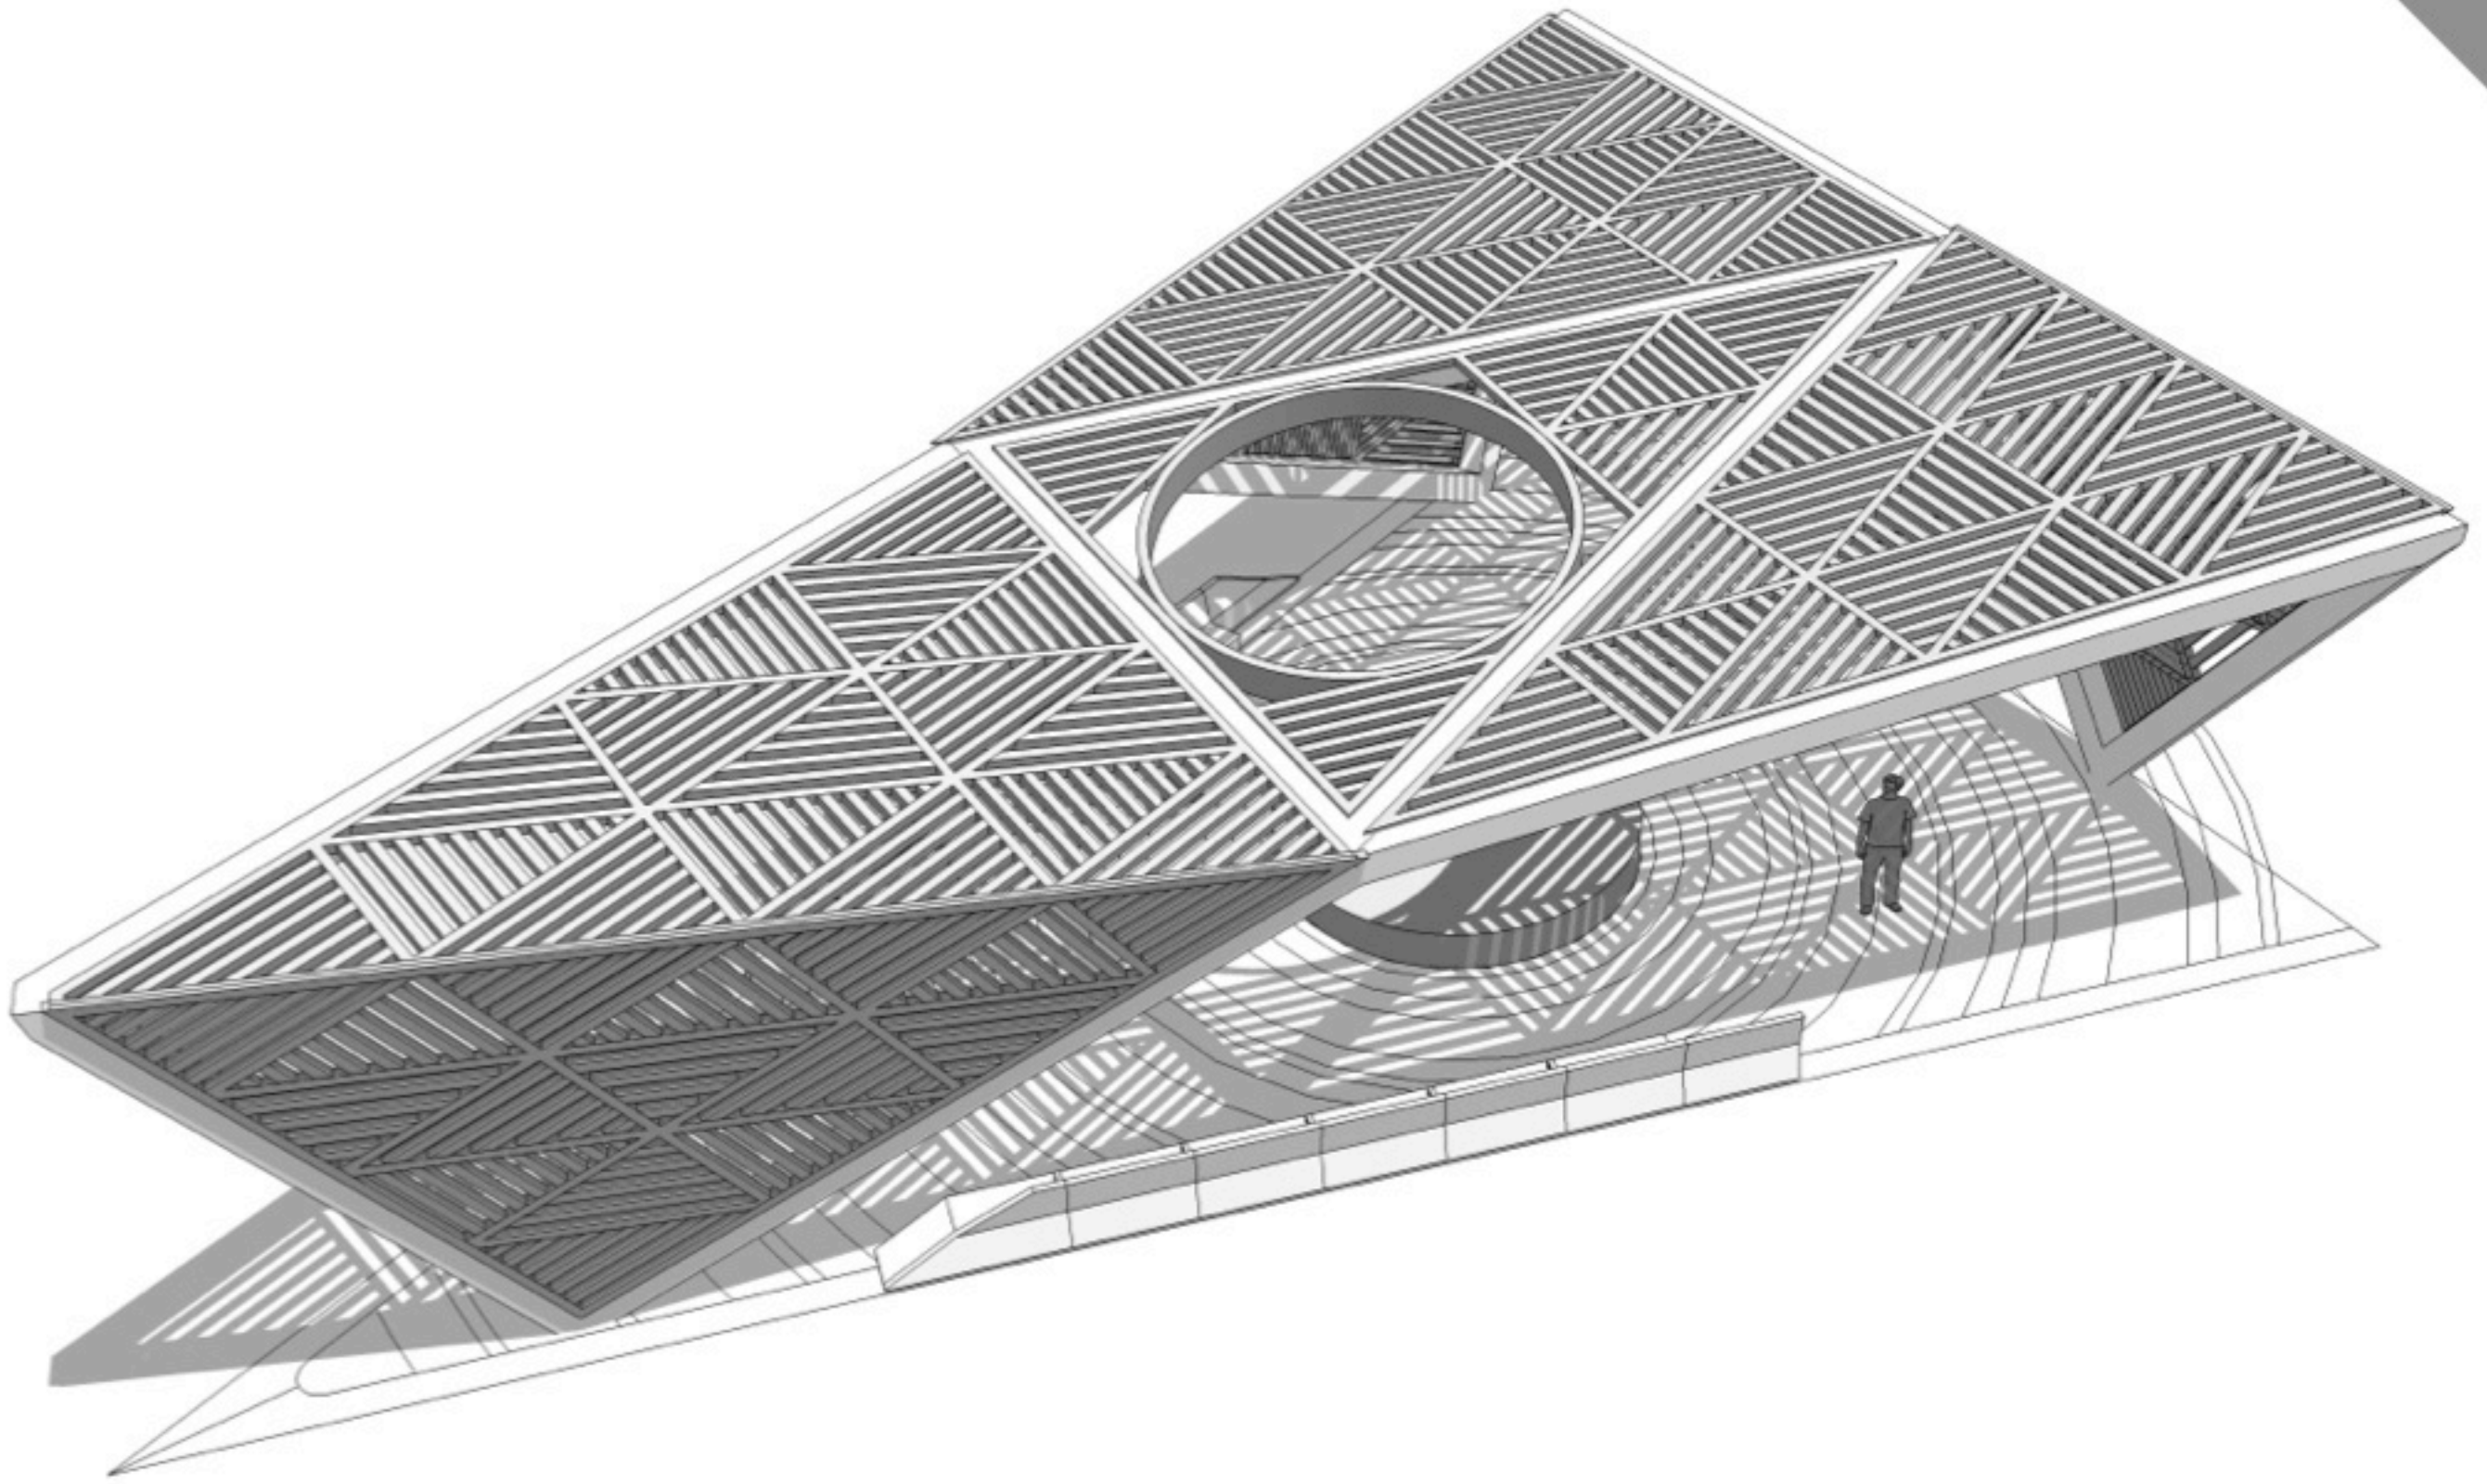


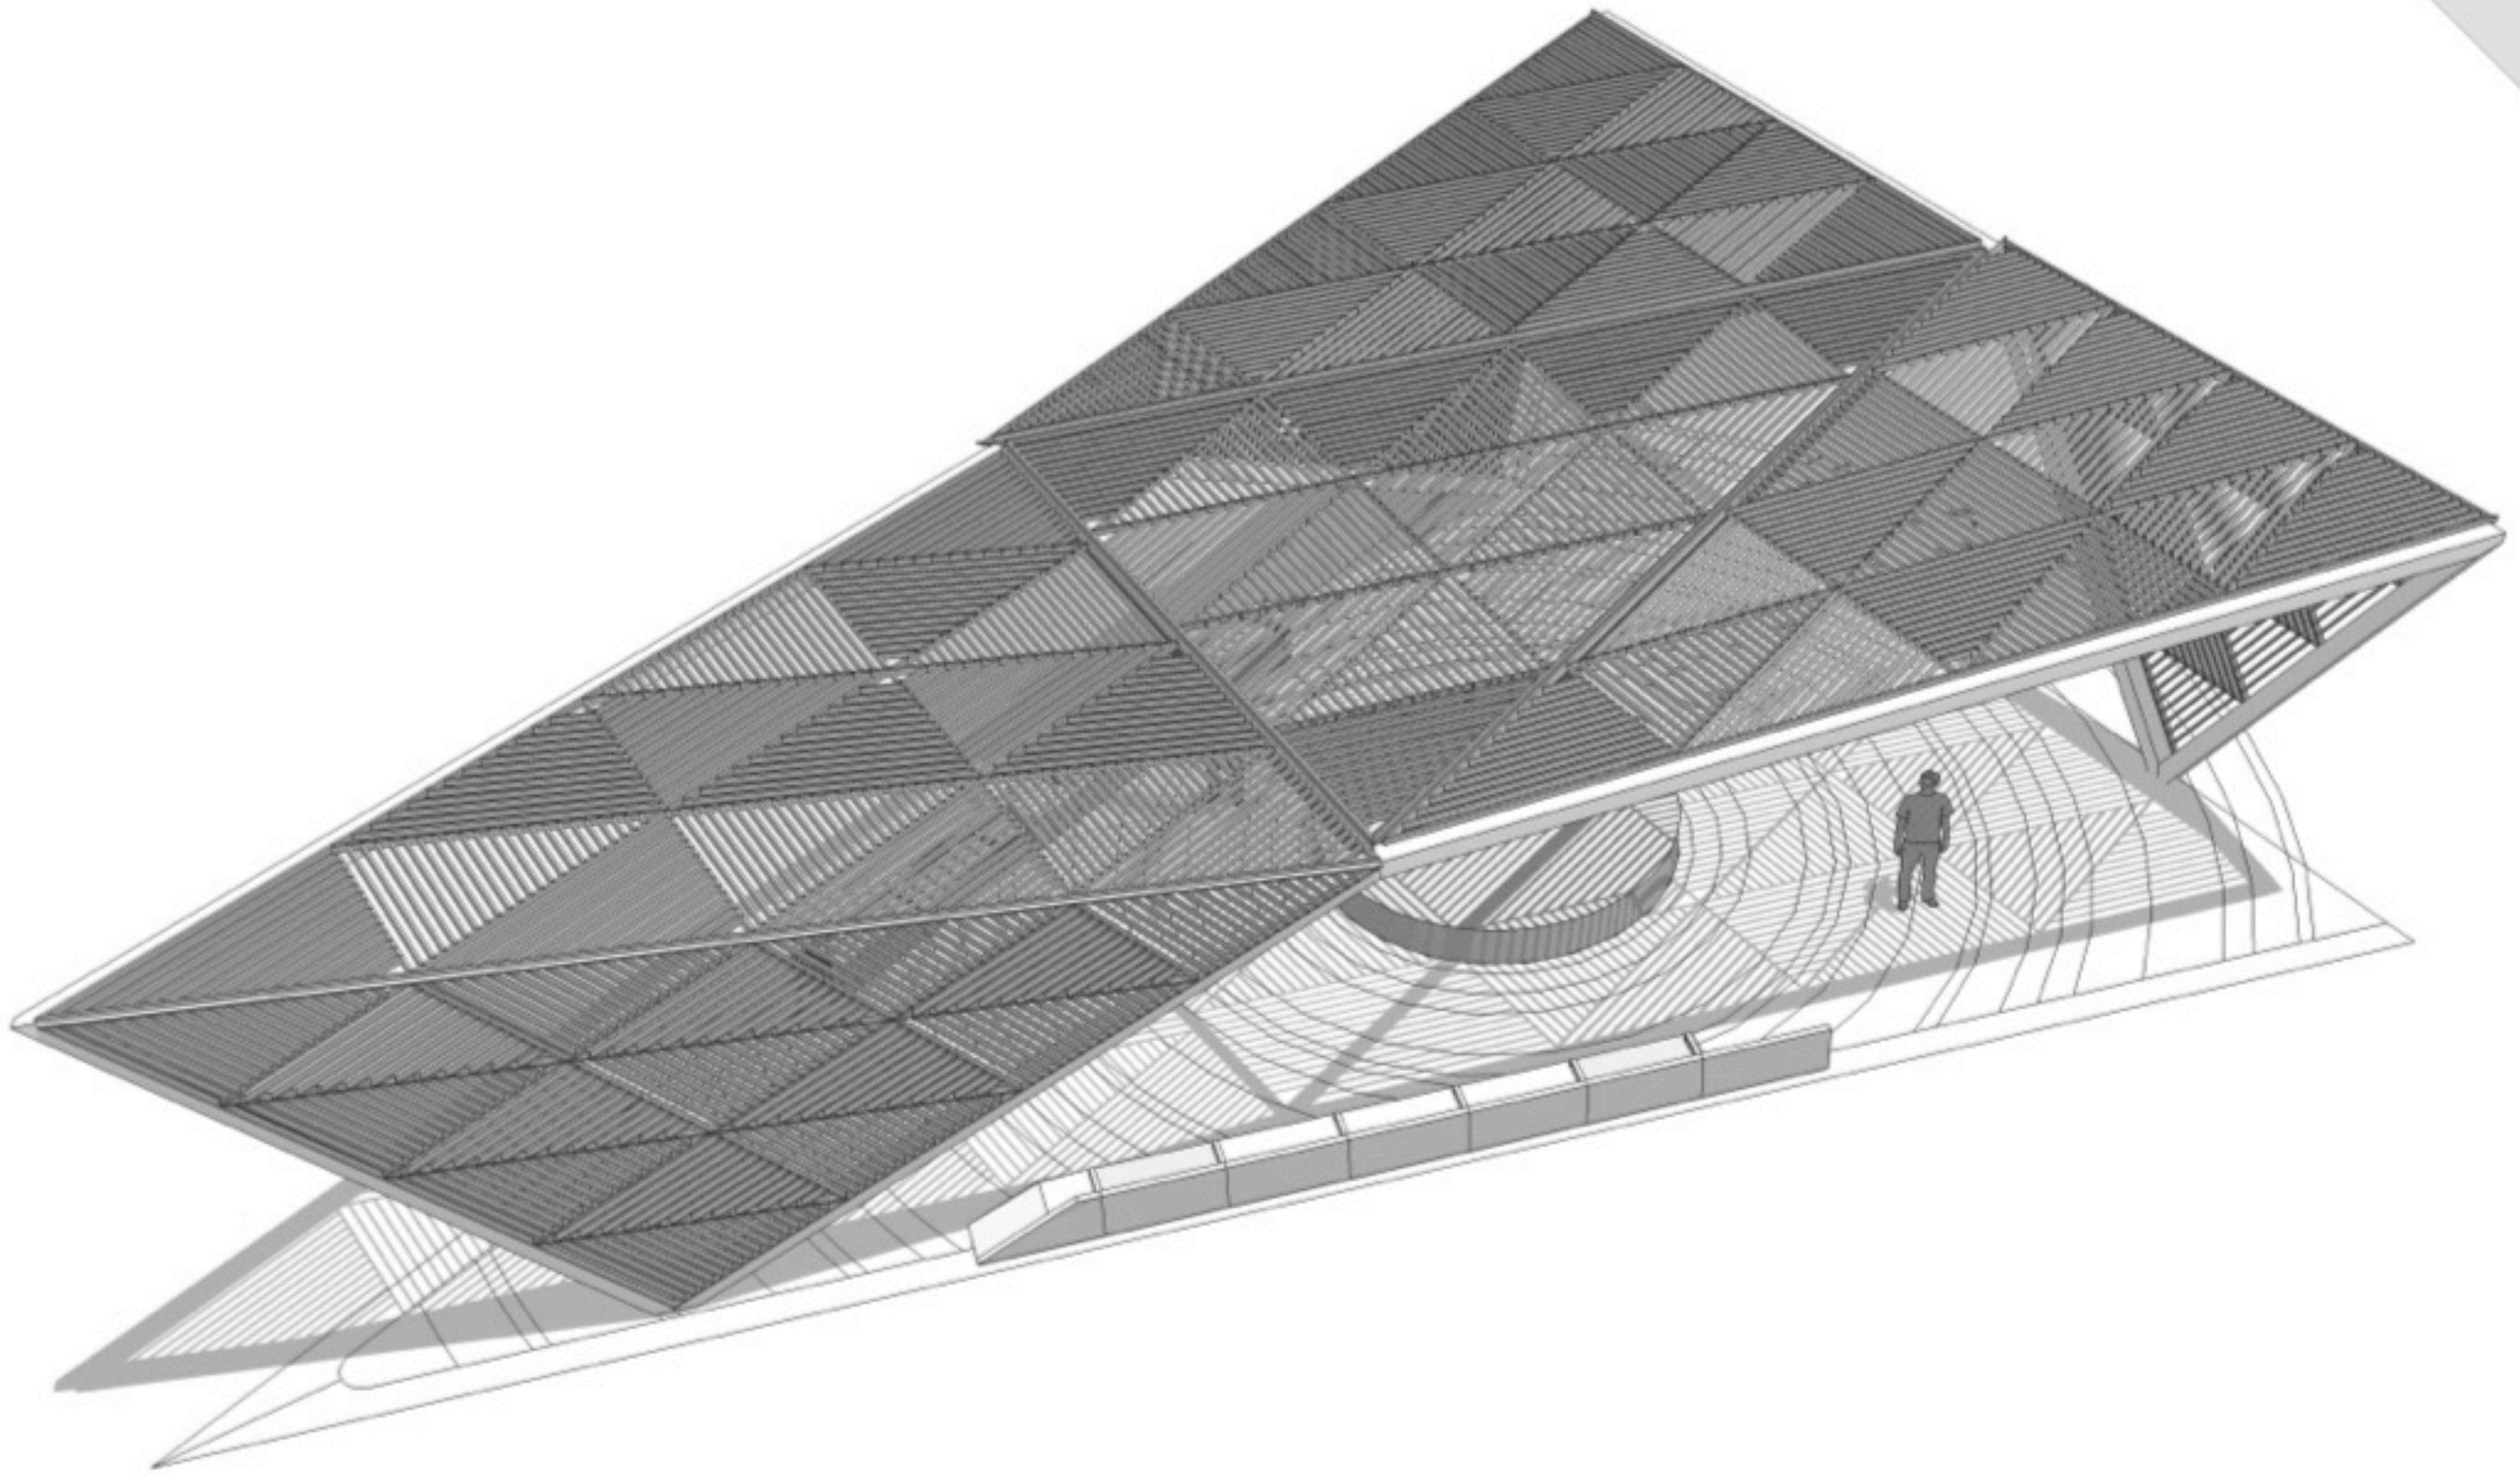

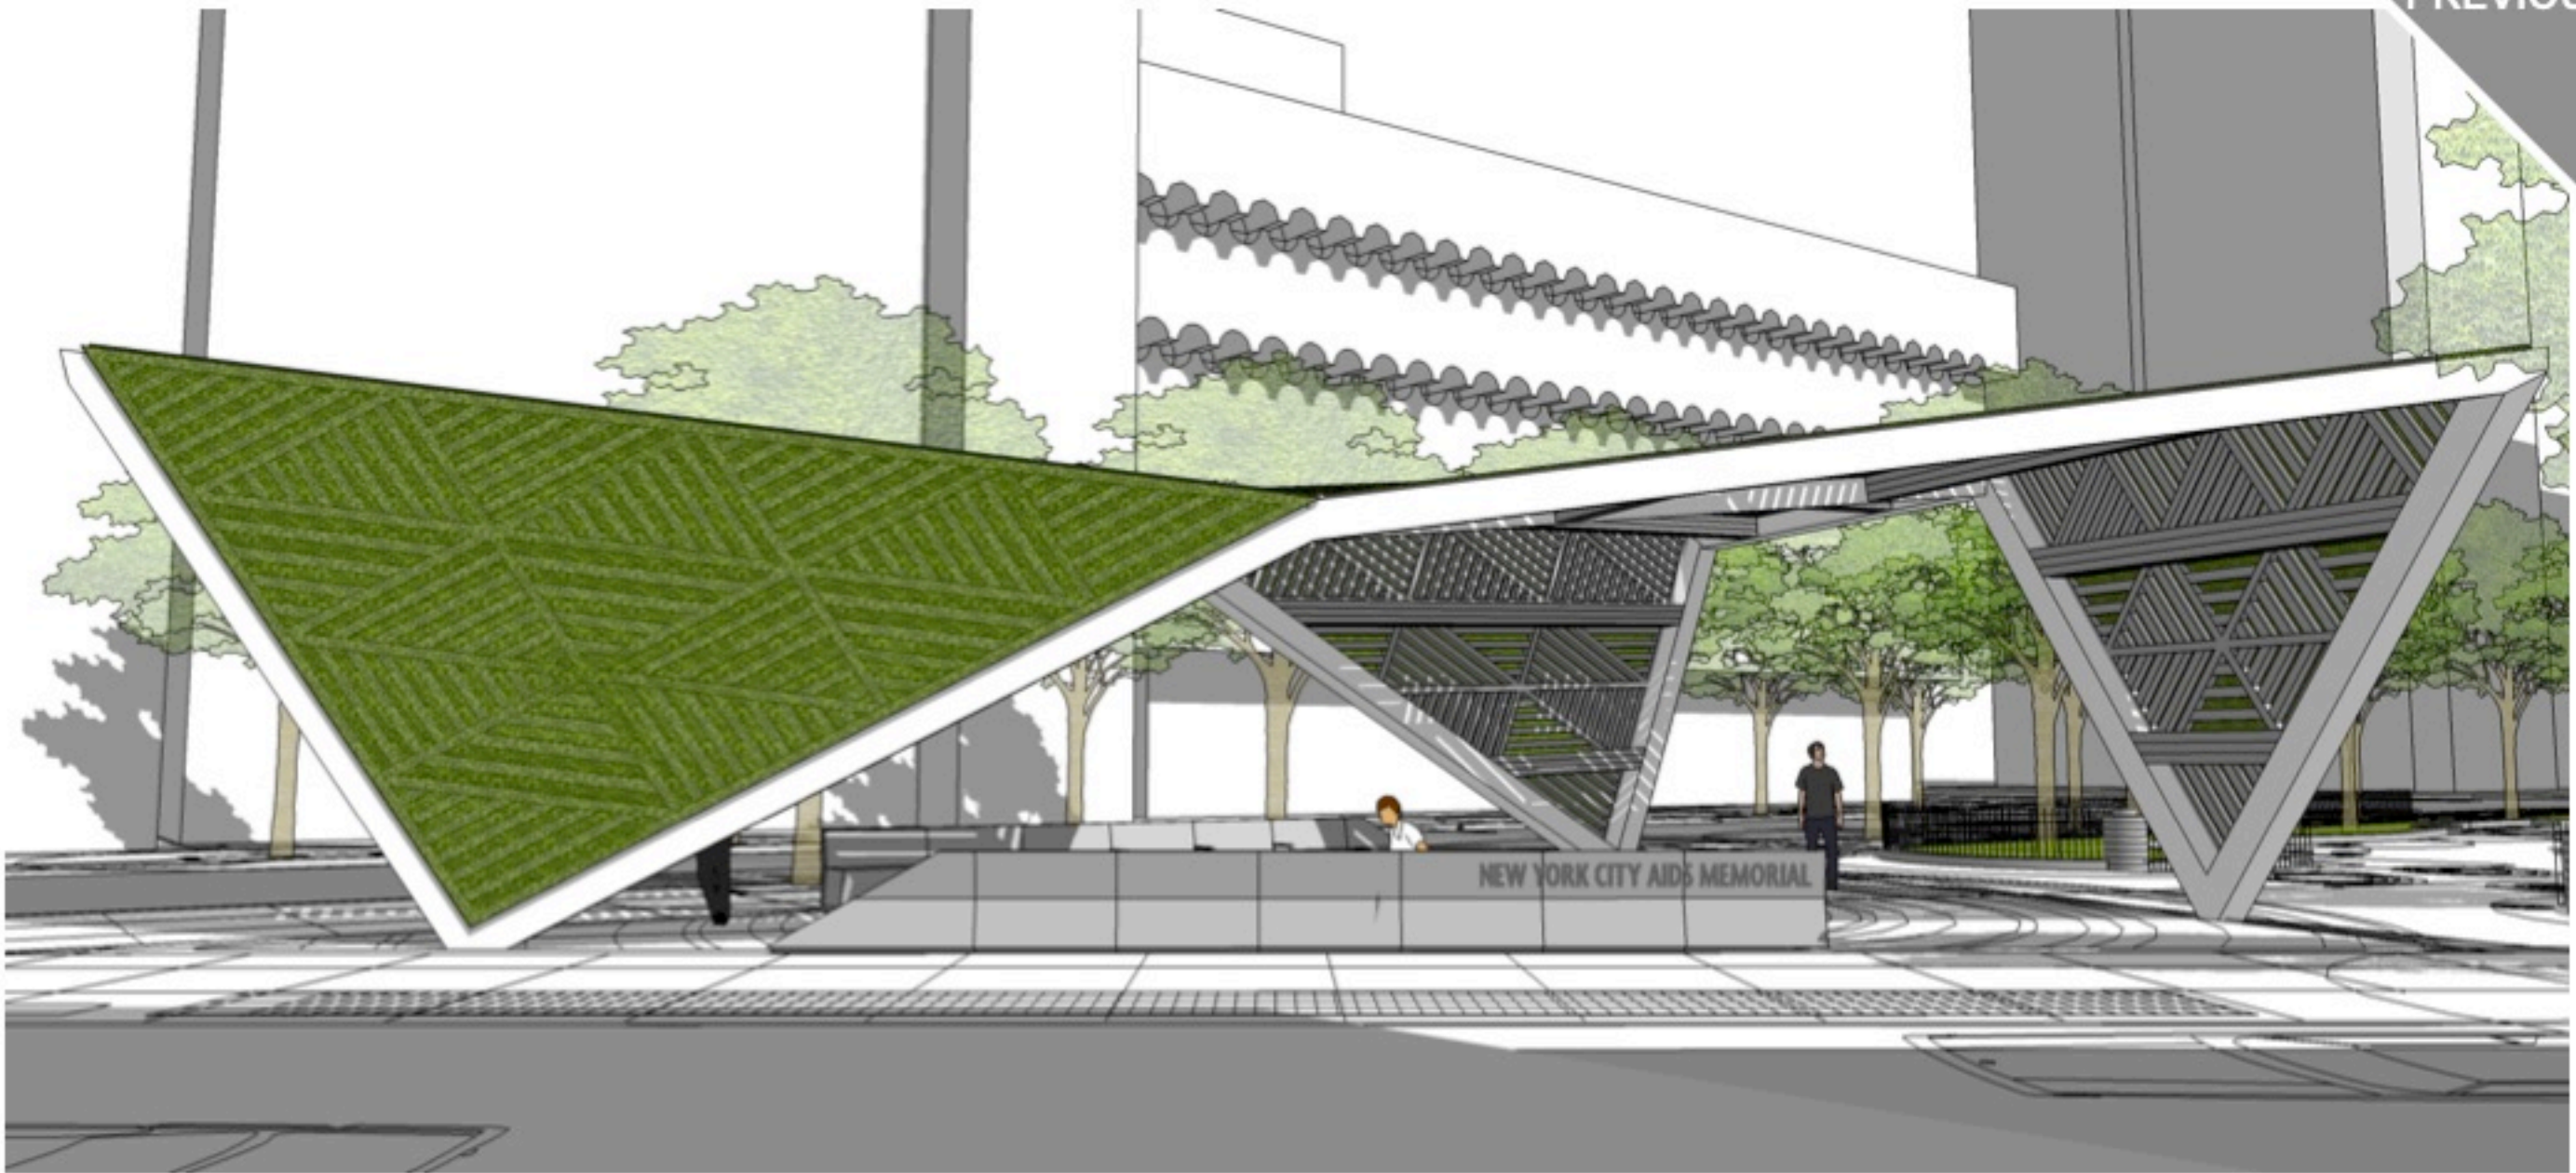




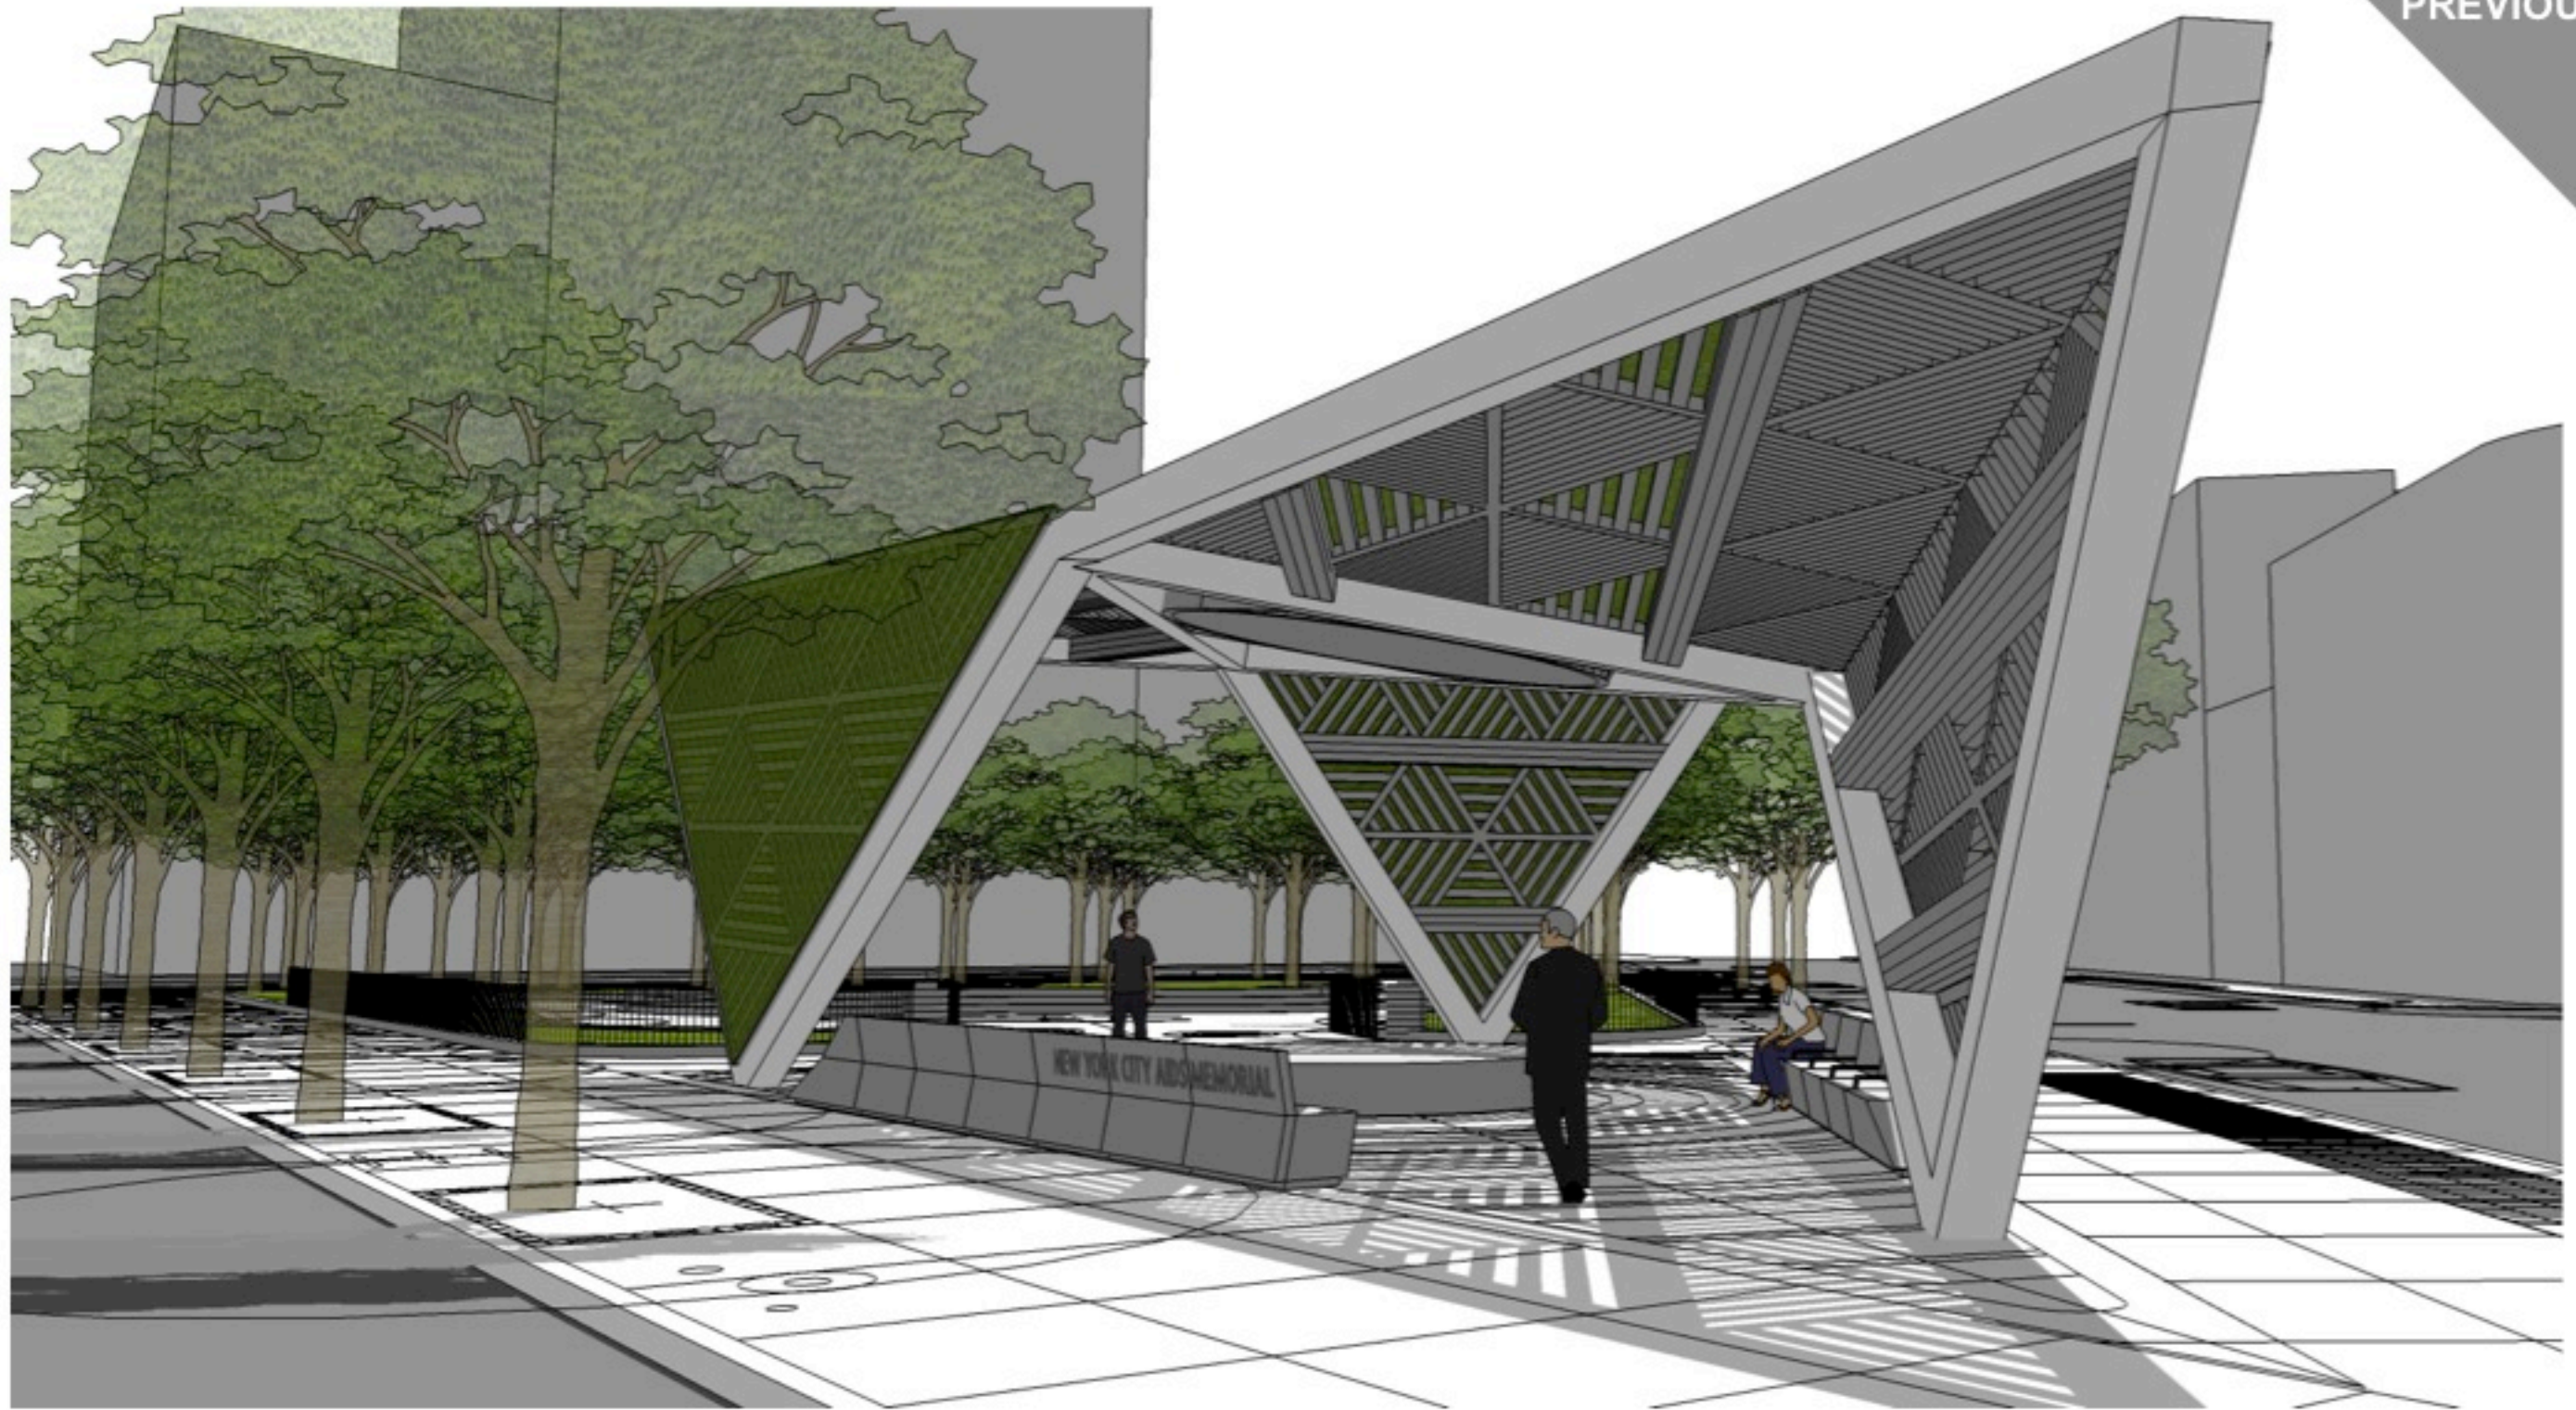


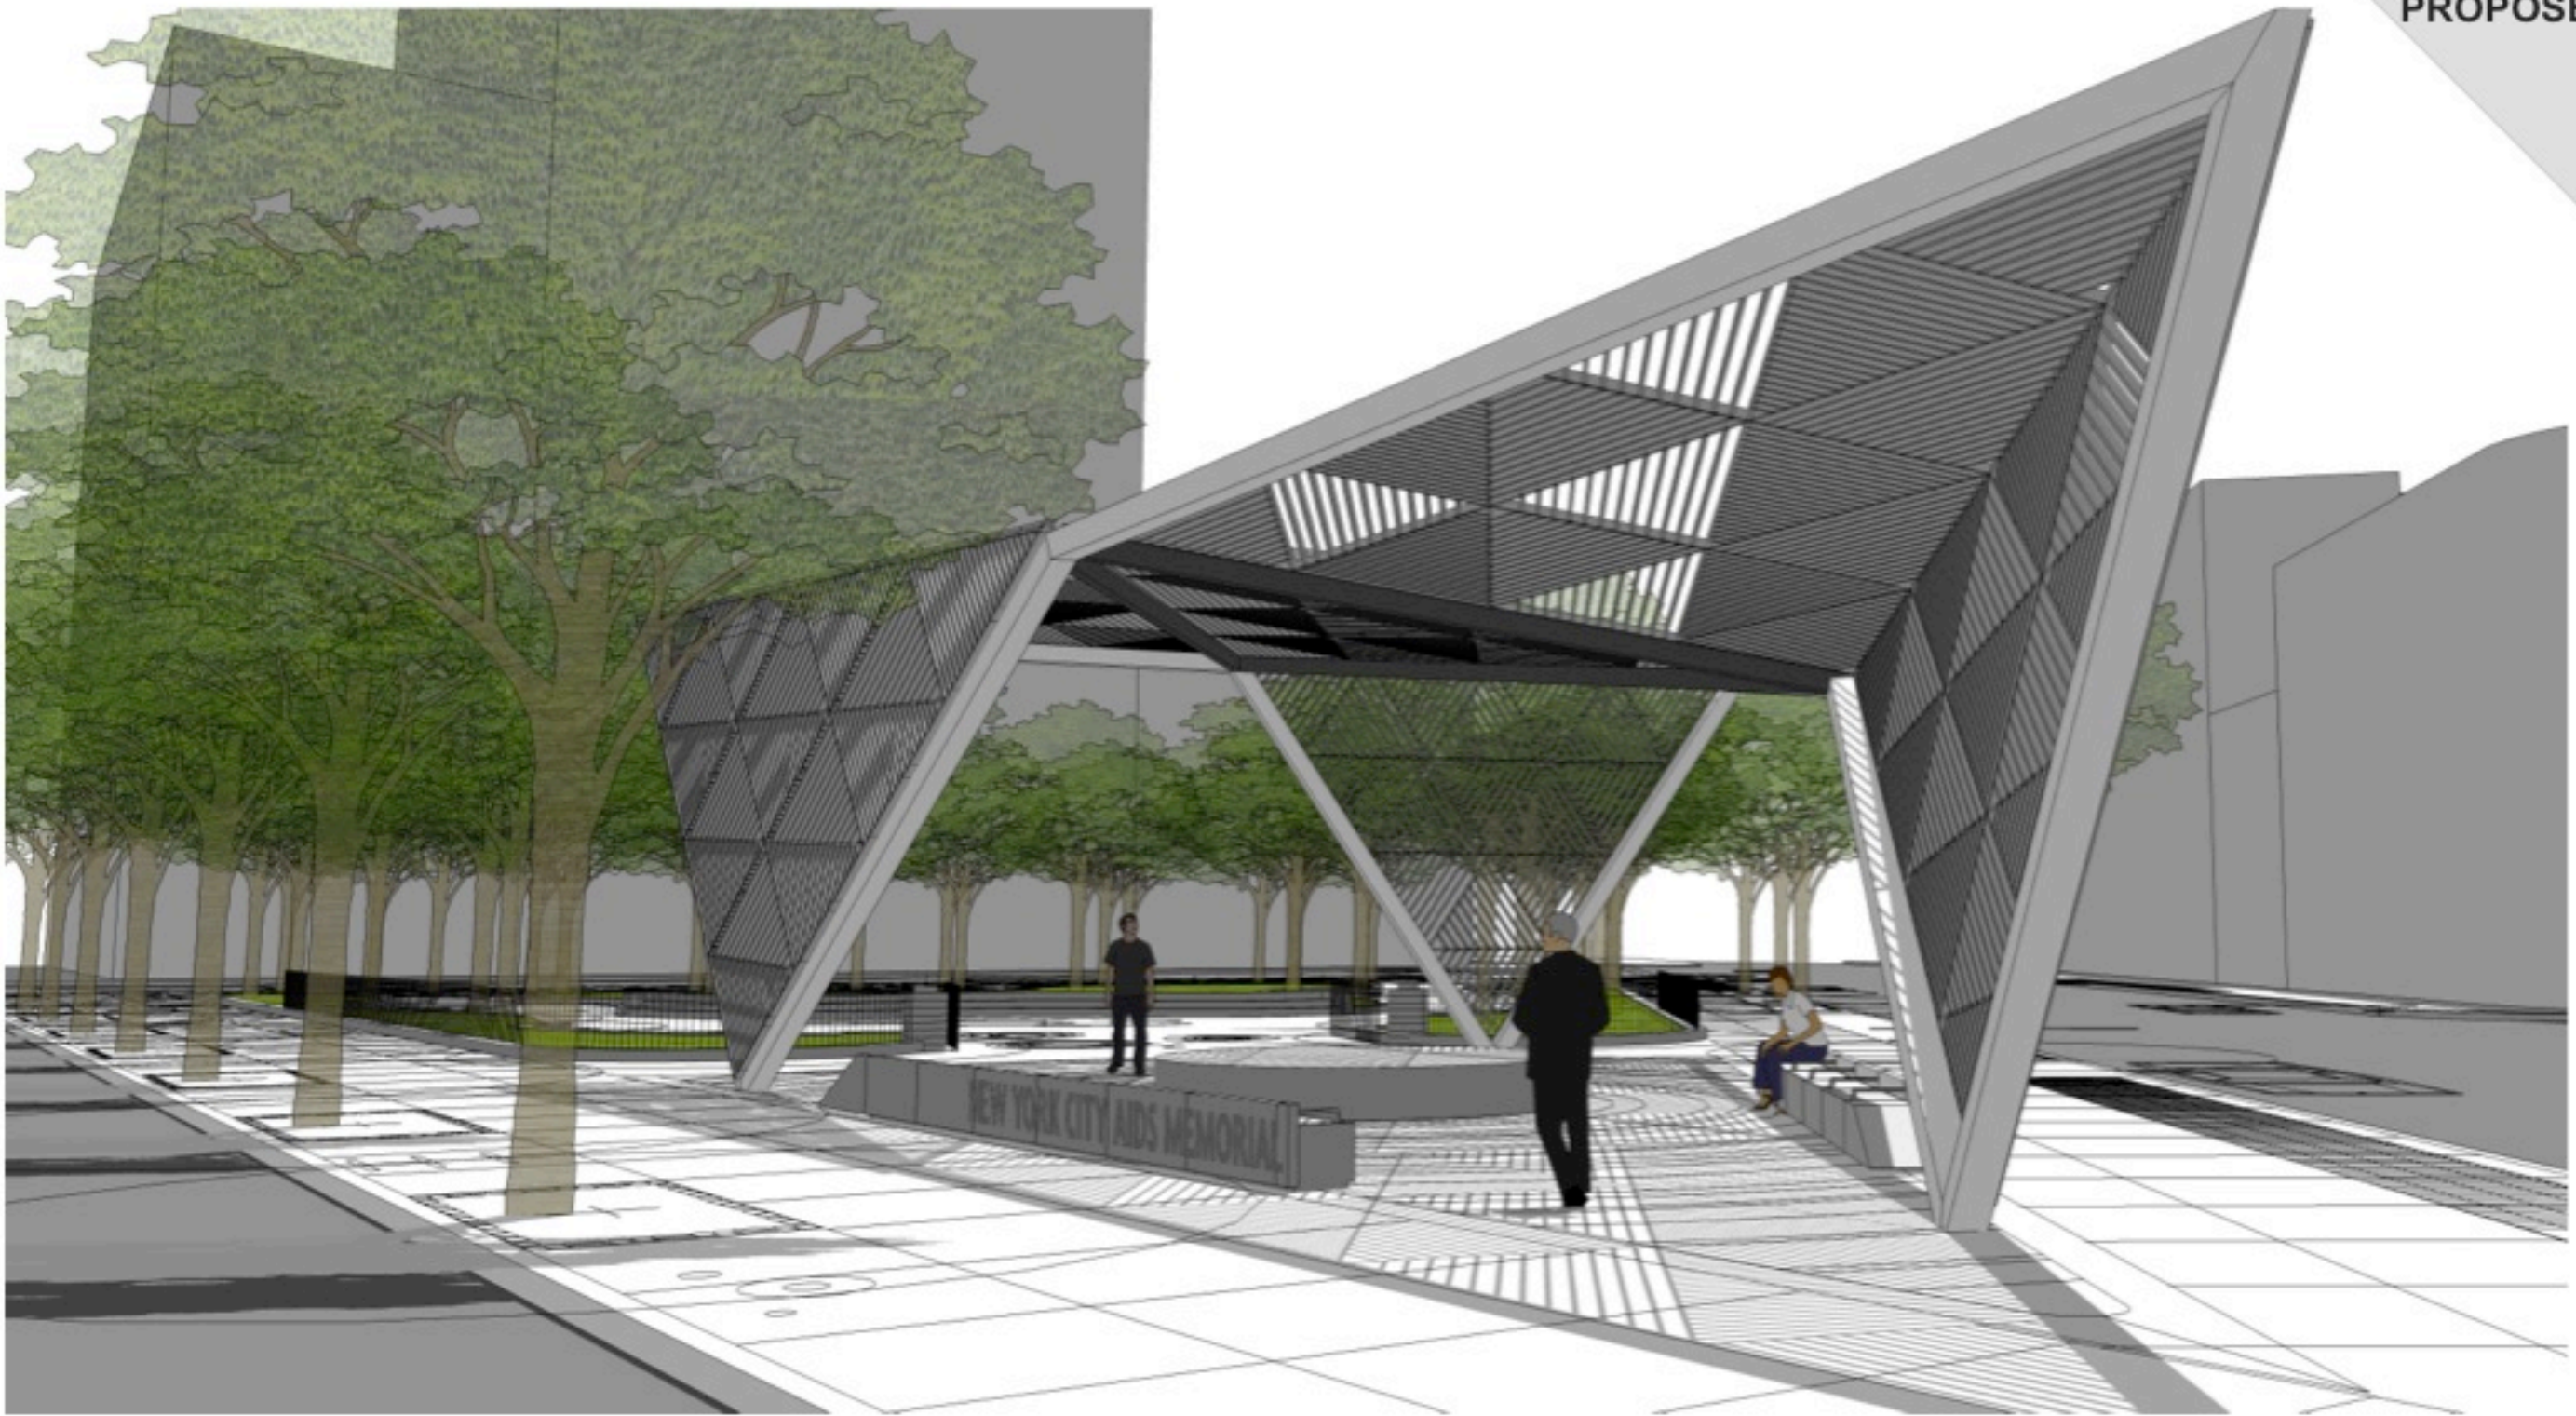


THE WATER FEATURE

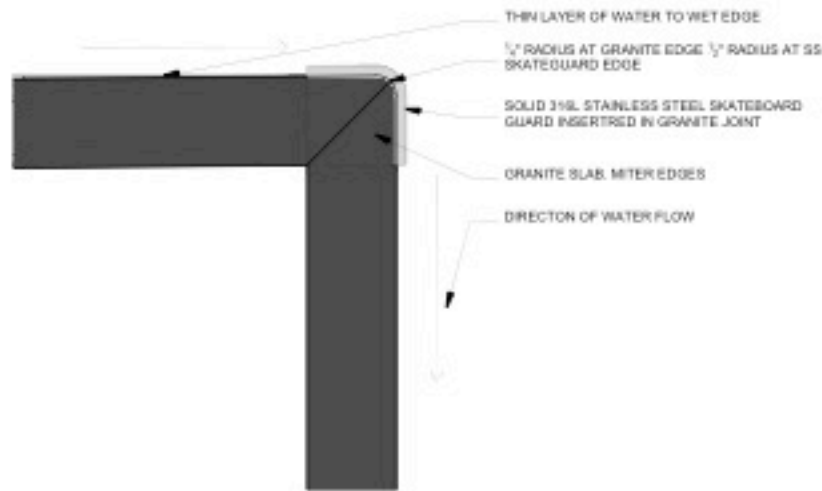


3 EDGE AND SKATEGUARD SECTION DETAIL
SCALE: 1" = 1'-0"

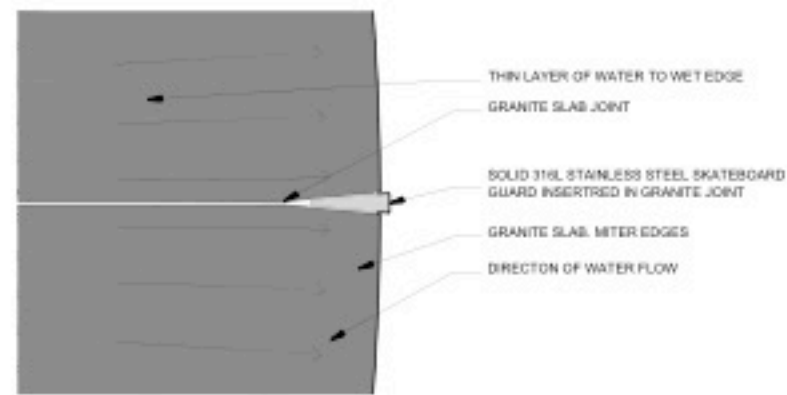


4 EDGE AND SKATEGUARD PLAN DETAIL
SCALE: 1" = 1'-0"

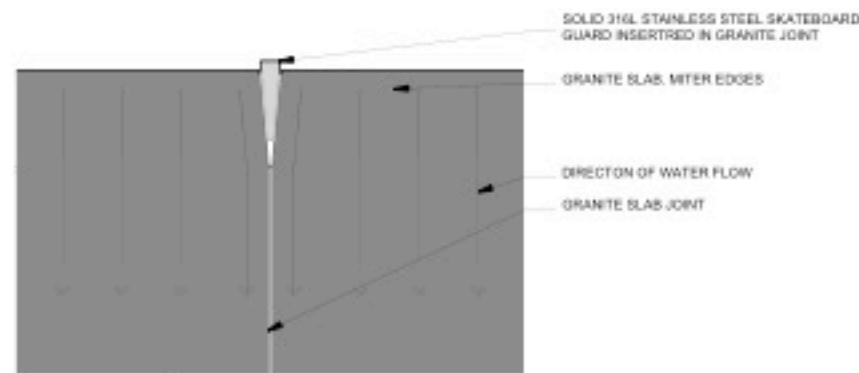

5 EDGE AND SKATEGUARD ELEVATION DETAIL
SCALE: 1" = 1'-0"

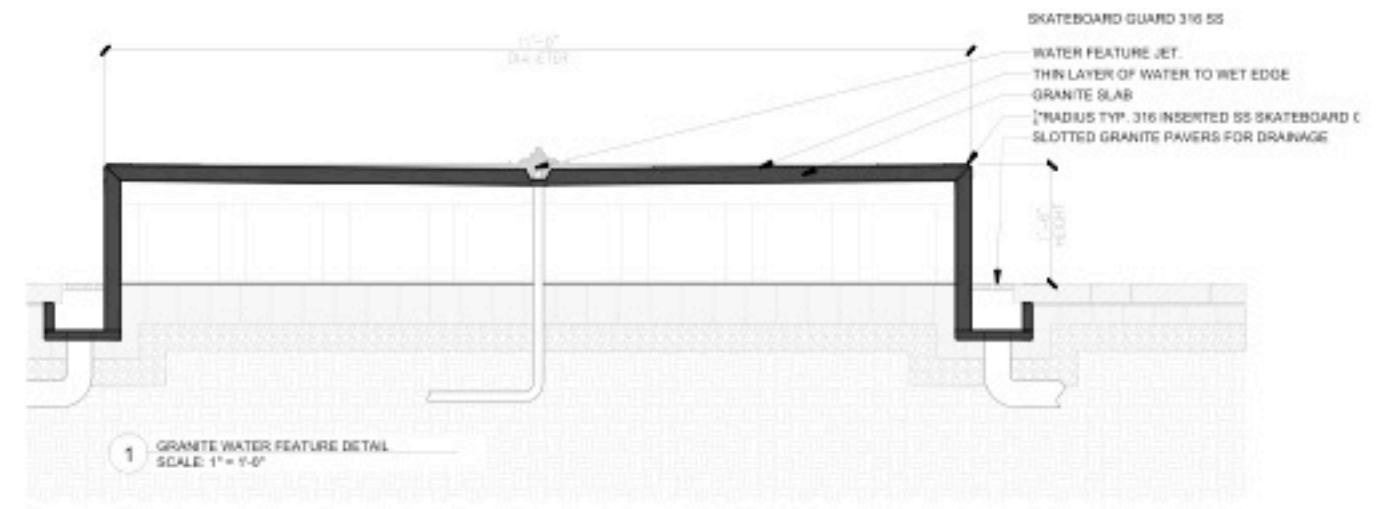


1 GRANITE WATER FEATURE DETAIL
SCALE: 1" = 1'-0"

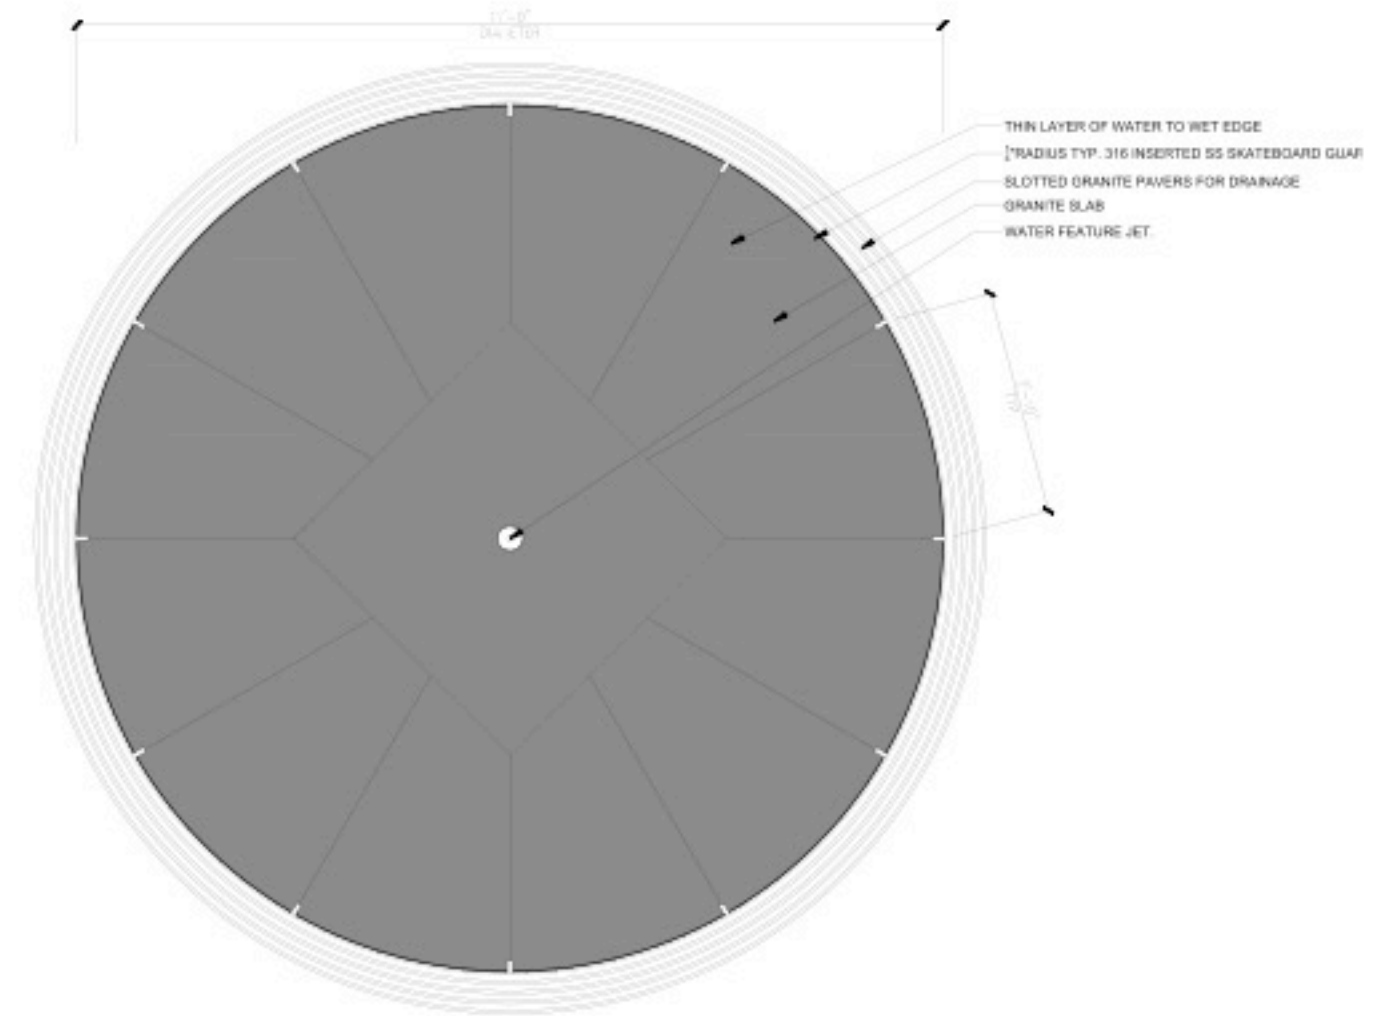


2 WATER FEATURE ENLARGED PLAN
SCALE: 1" = 1'-0"


THE WATER FEATURE

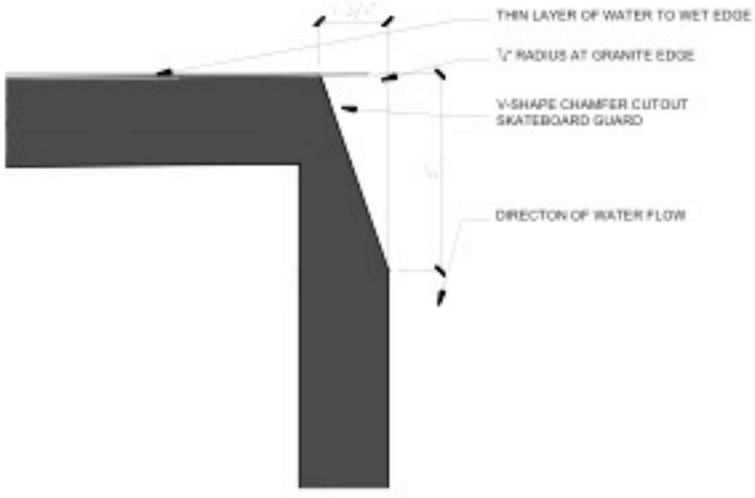


3 EDGE AND SKATEGUARD SECTION DETAIL
SCALE: 6" = 1'-0"

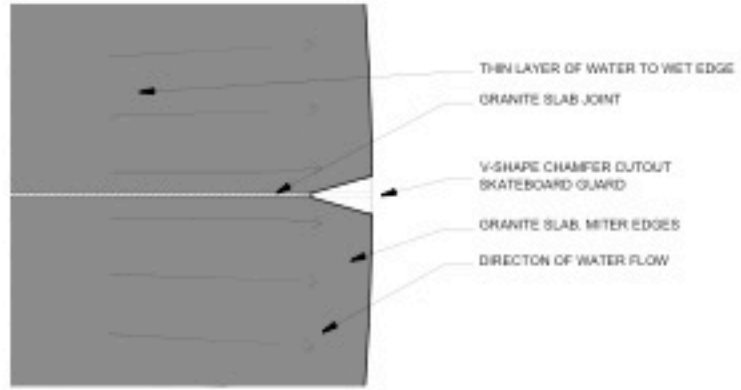


4 EDGE AND SKATEGUARD PLAN DETAIL
SCALE: 6" = 1'-0"

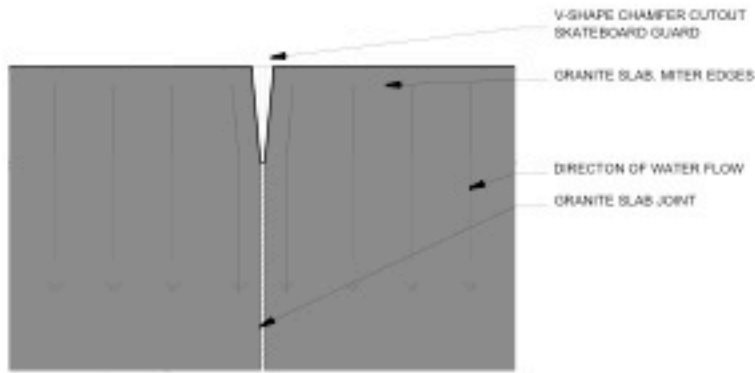

5 EDGE AND SKATEGUARD ELEVATION DETAIL
SCALE: 6" = 1'-0"

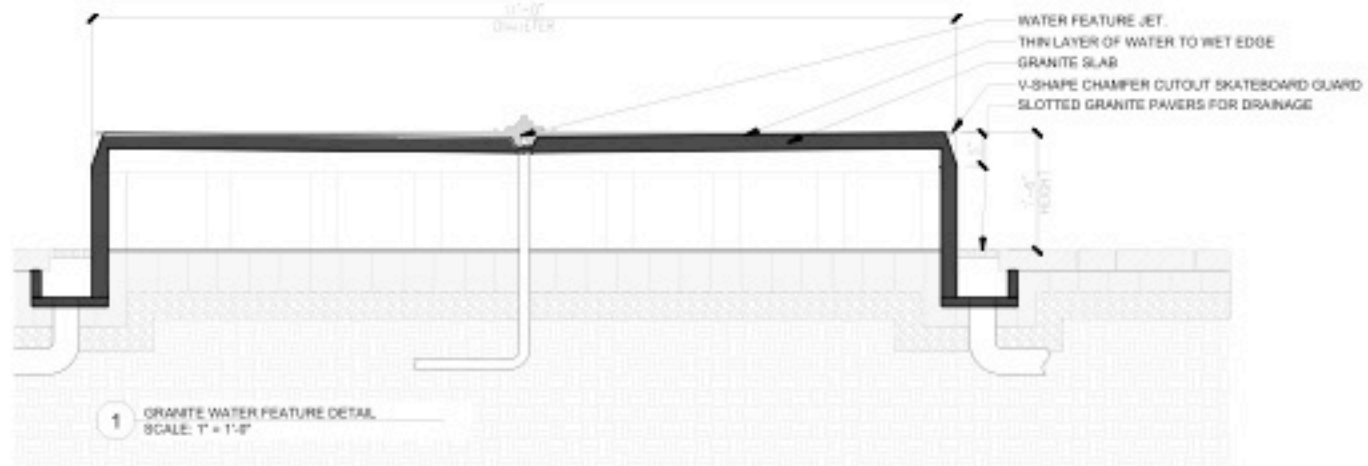

1 GRANITE WATER FEATURE DETAIL
SCALE: 1" = 1'-0"

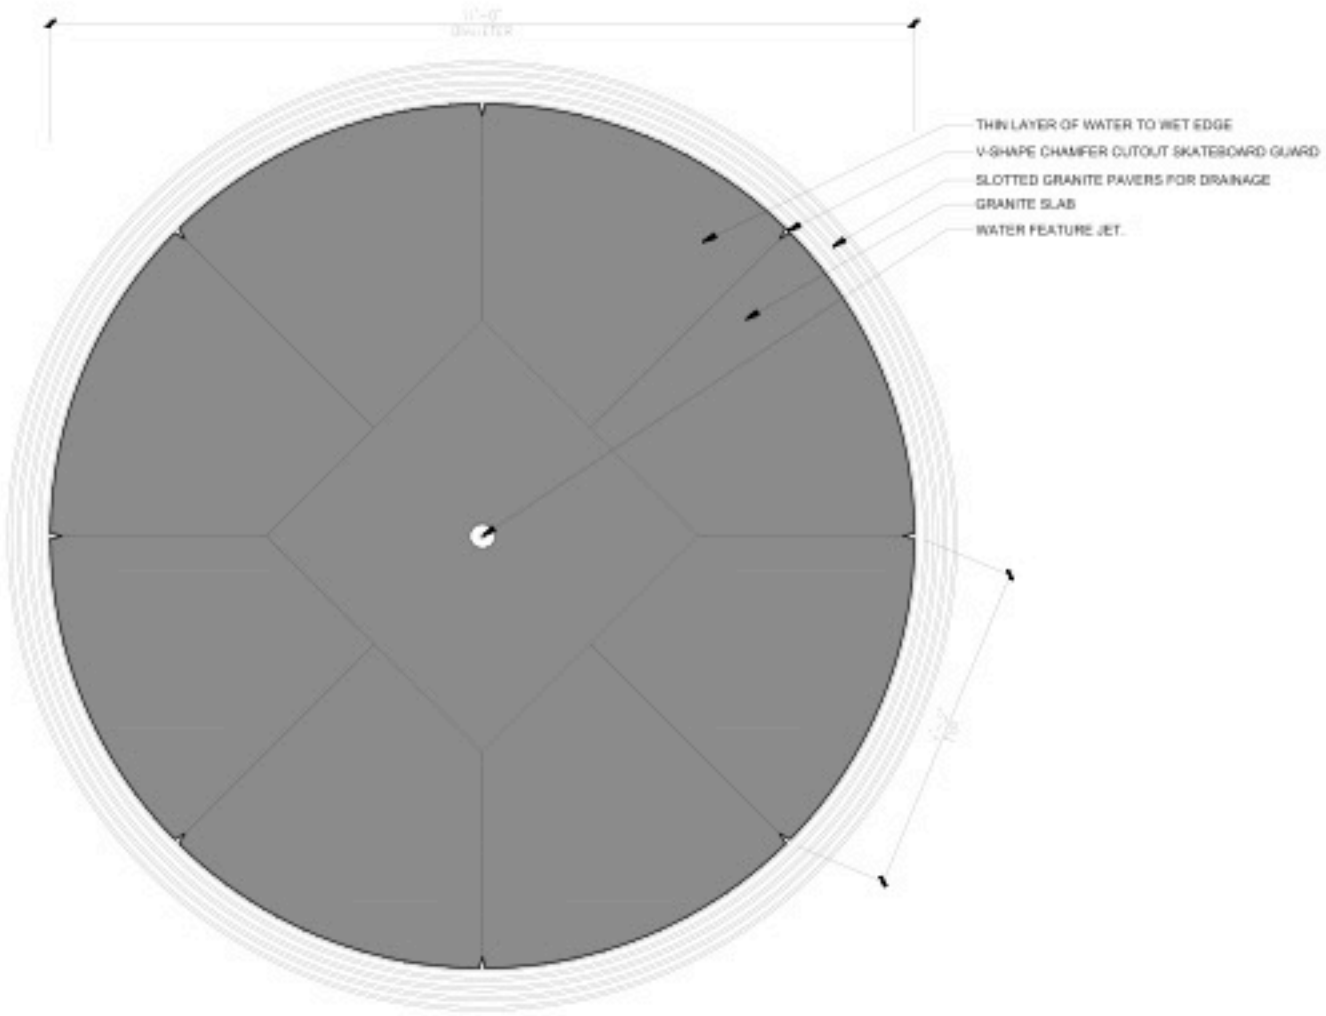


2 WATER FEATURE ENLARGED PLAN
SCALE: 1" = 1'-0"


THE SEATING – HIGH BACK

ADA COMPLIANT

- Length: 30' long benches, separated into 4' sections with railing/skateboard guards
- Seating Dimensions: 18" deep seating, 18" high, 18" back rest with 10 degrees incline, 4" high armrest
- Total seating proposed: 56 LF bench seating with back
- Material: granite


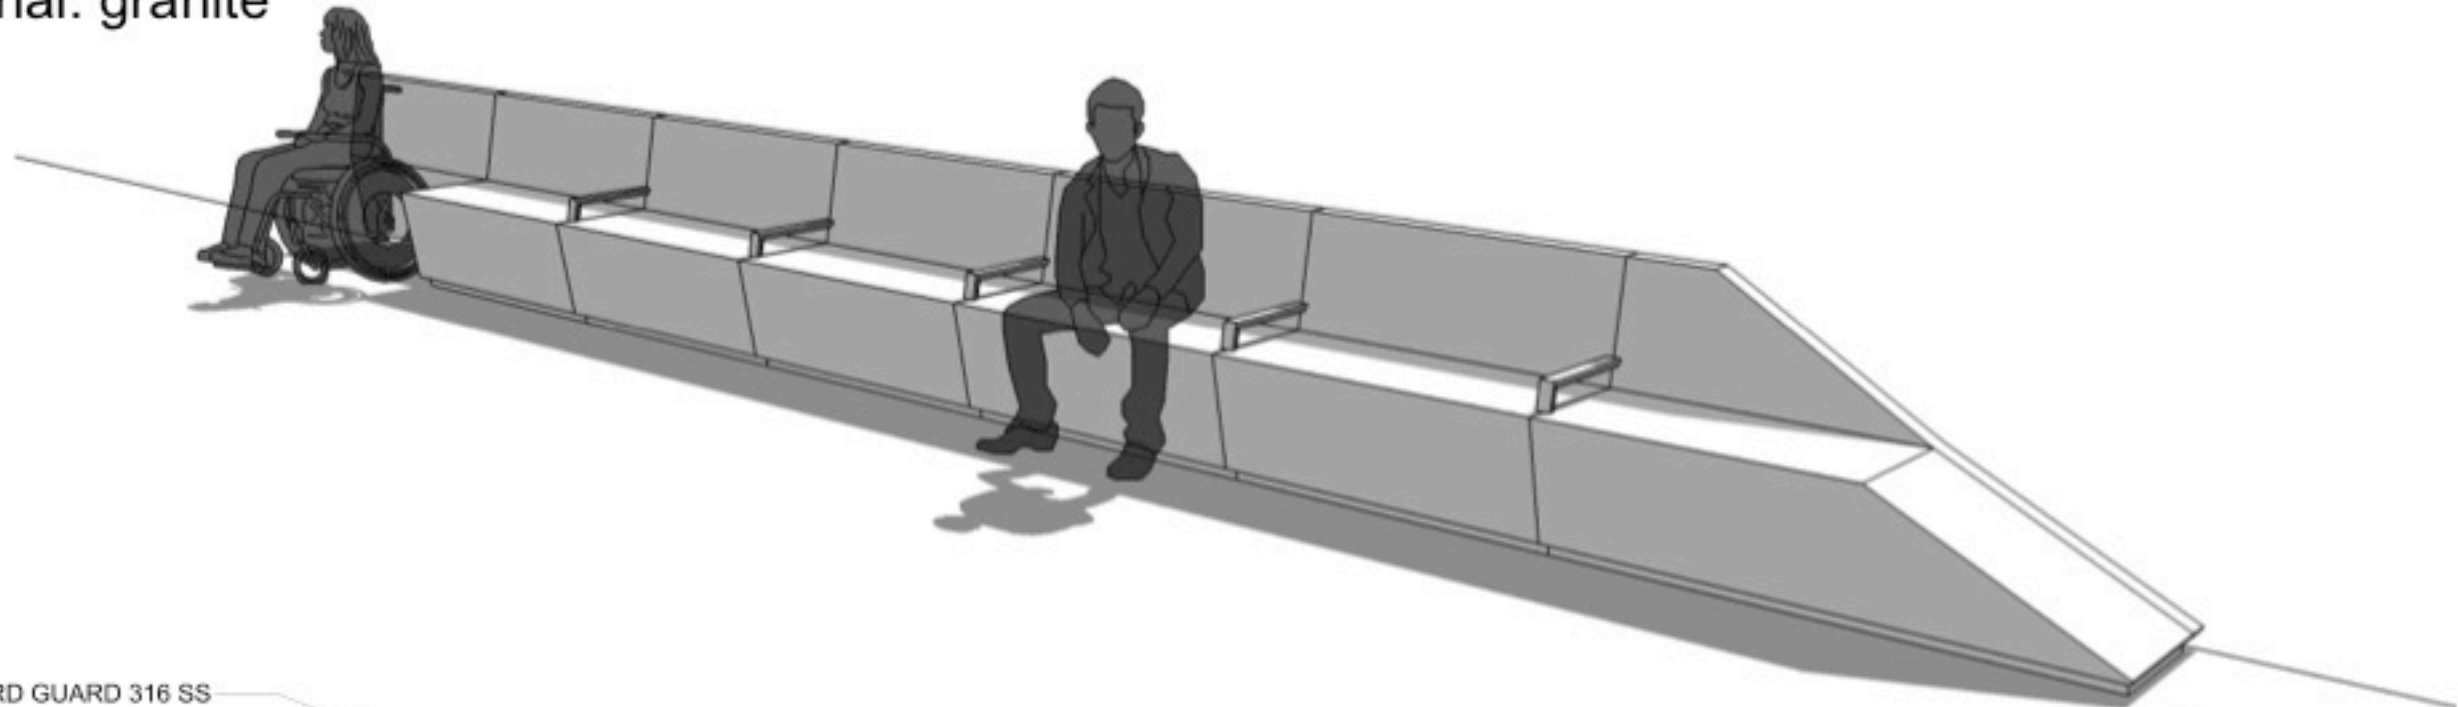


SKATEBOARD GUARD 316 SS
 ARMREST 316 SS
 GRANITE CLAD SEAT WALL

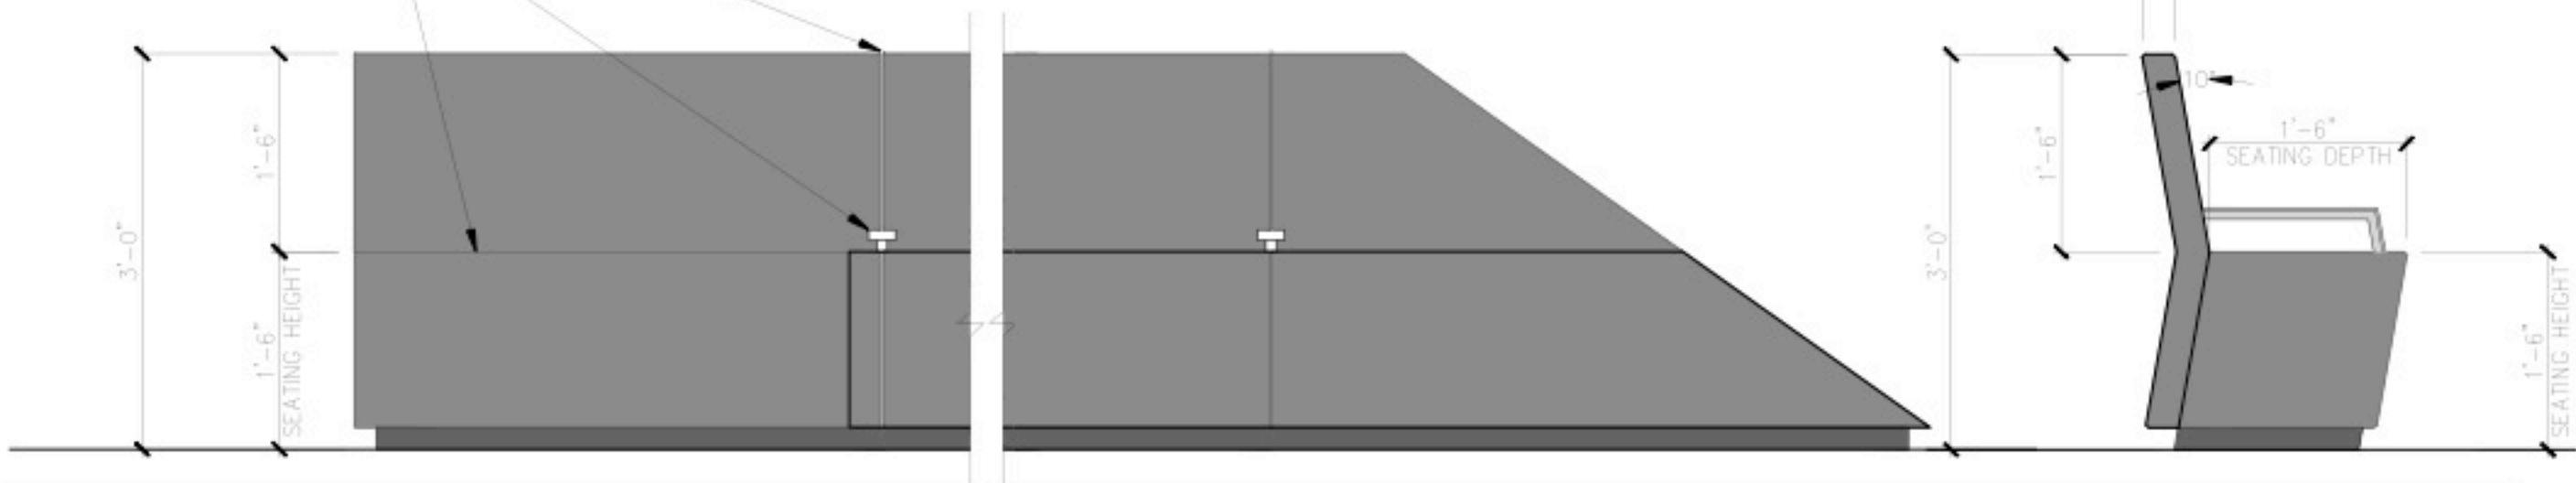


THE SEATING – LOW BACK ADA COMPLIANT

- Length: 30' long benches, separated into 4' sections with railing/skateboard guards
- Seating Dimensions: 18" deep seating, 18" high, 6" back rest with 10 degrees incline, 4" high armrest
- Total seating proposed: 56 LF bench seating with back
- Material: granite

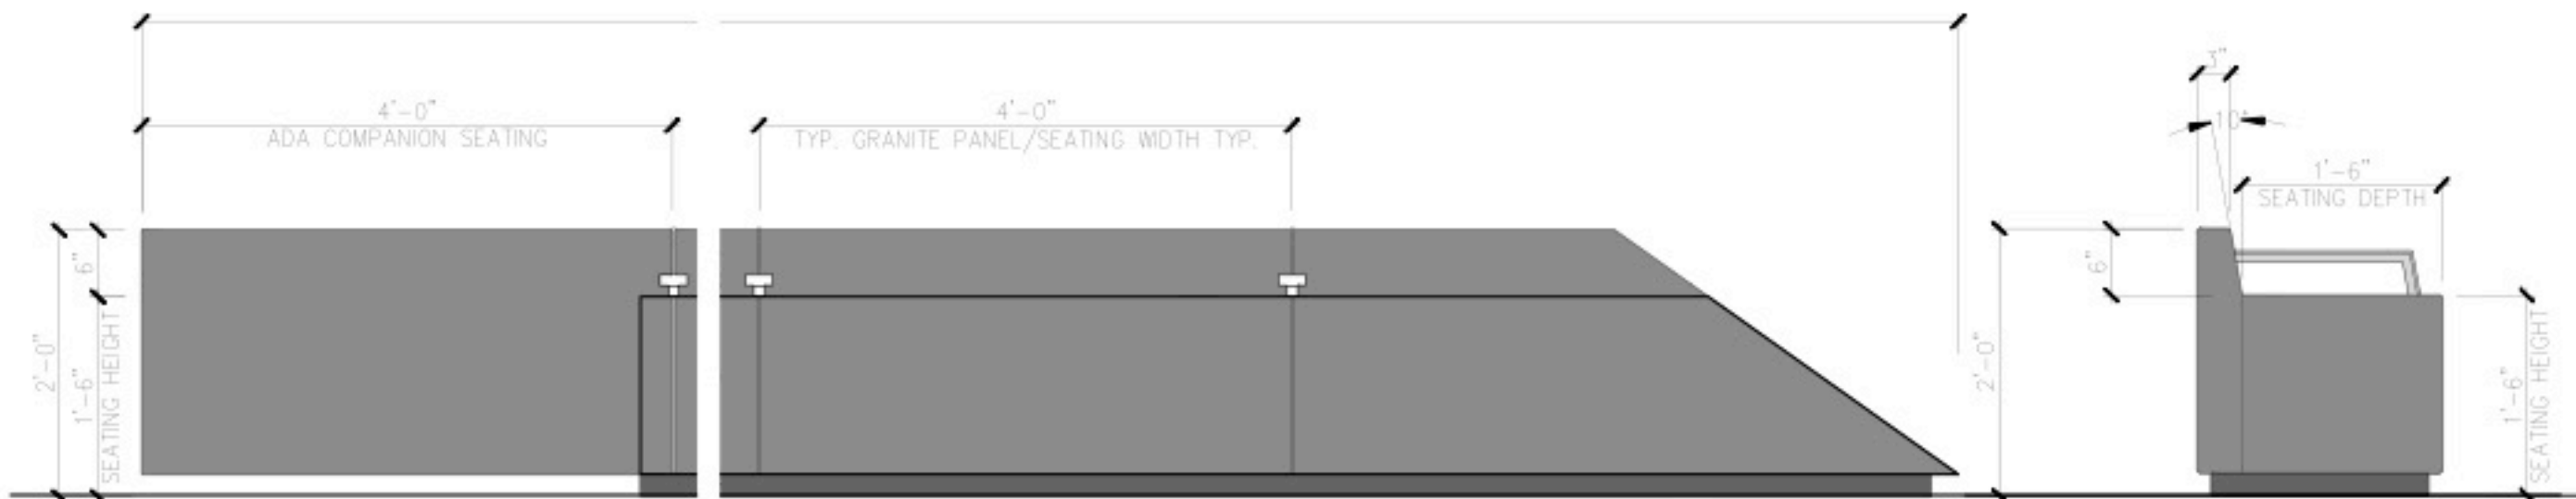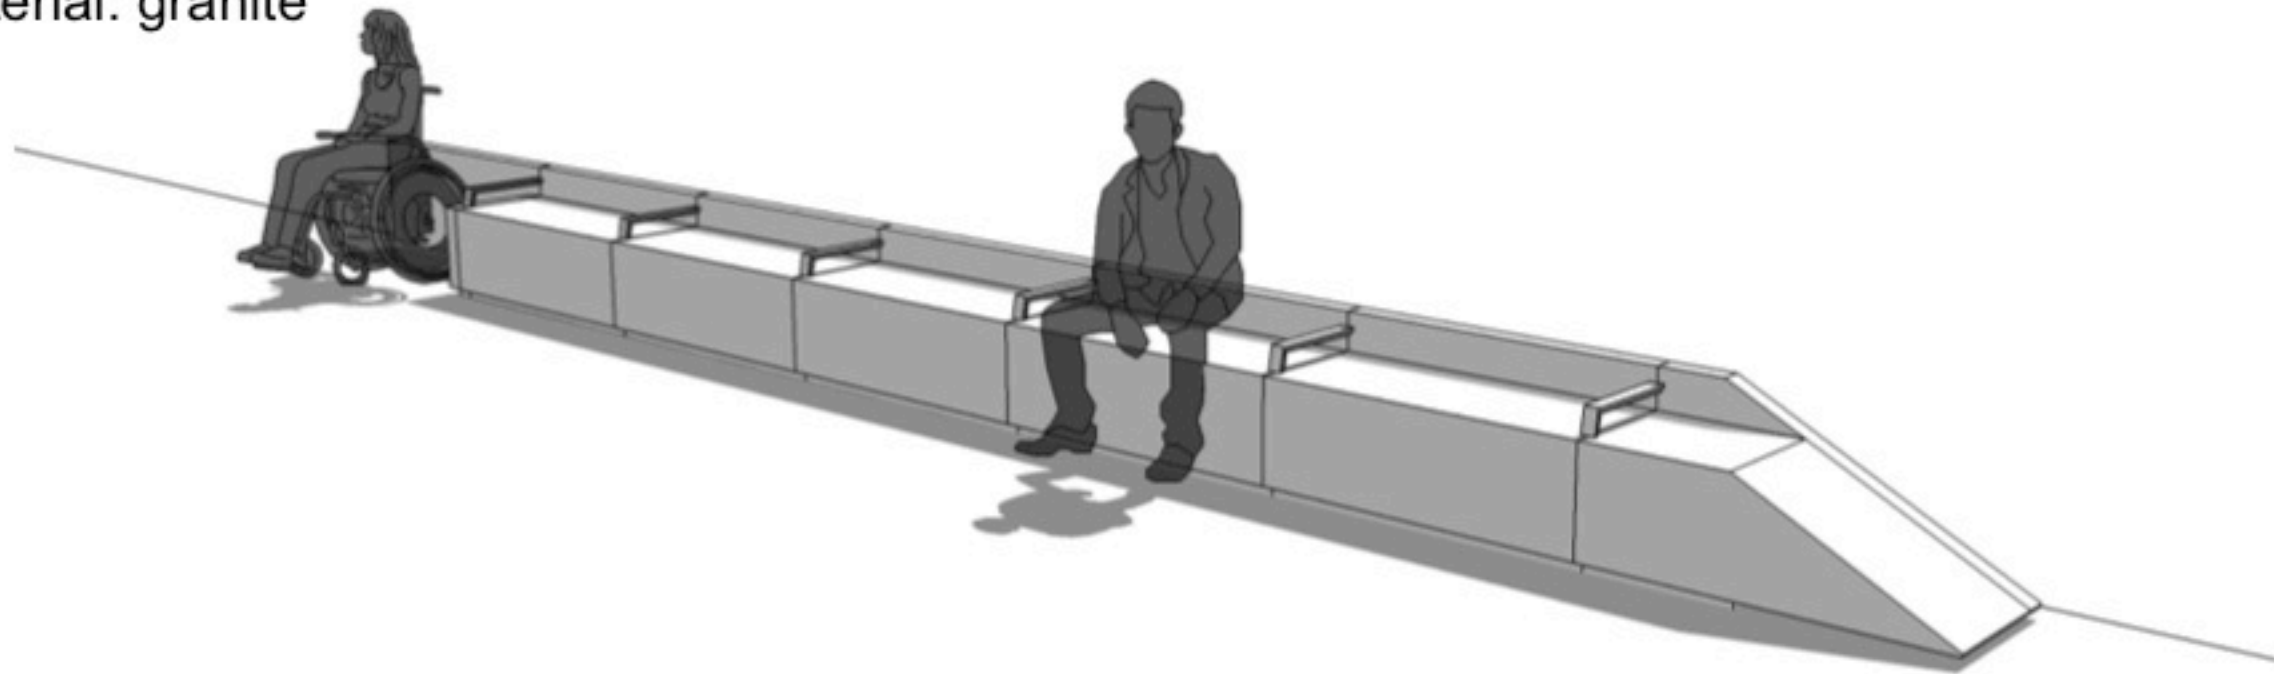


THE PAVING PATTERN

New York City AIDS Memorial and St. Vincent's Park

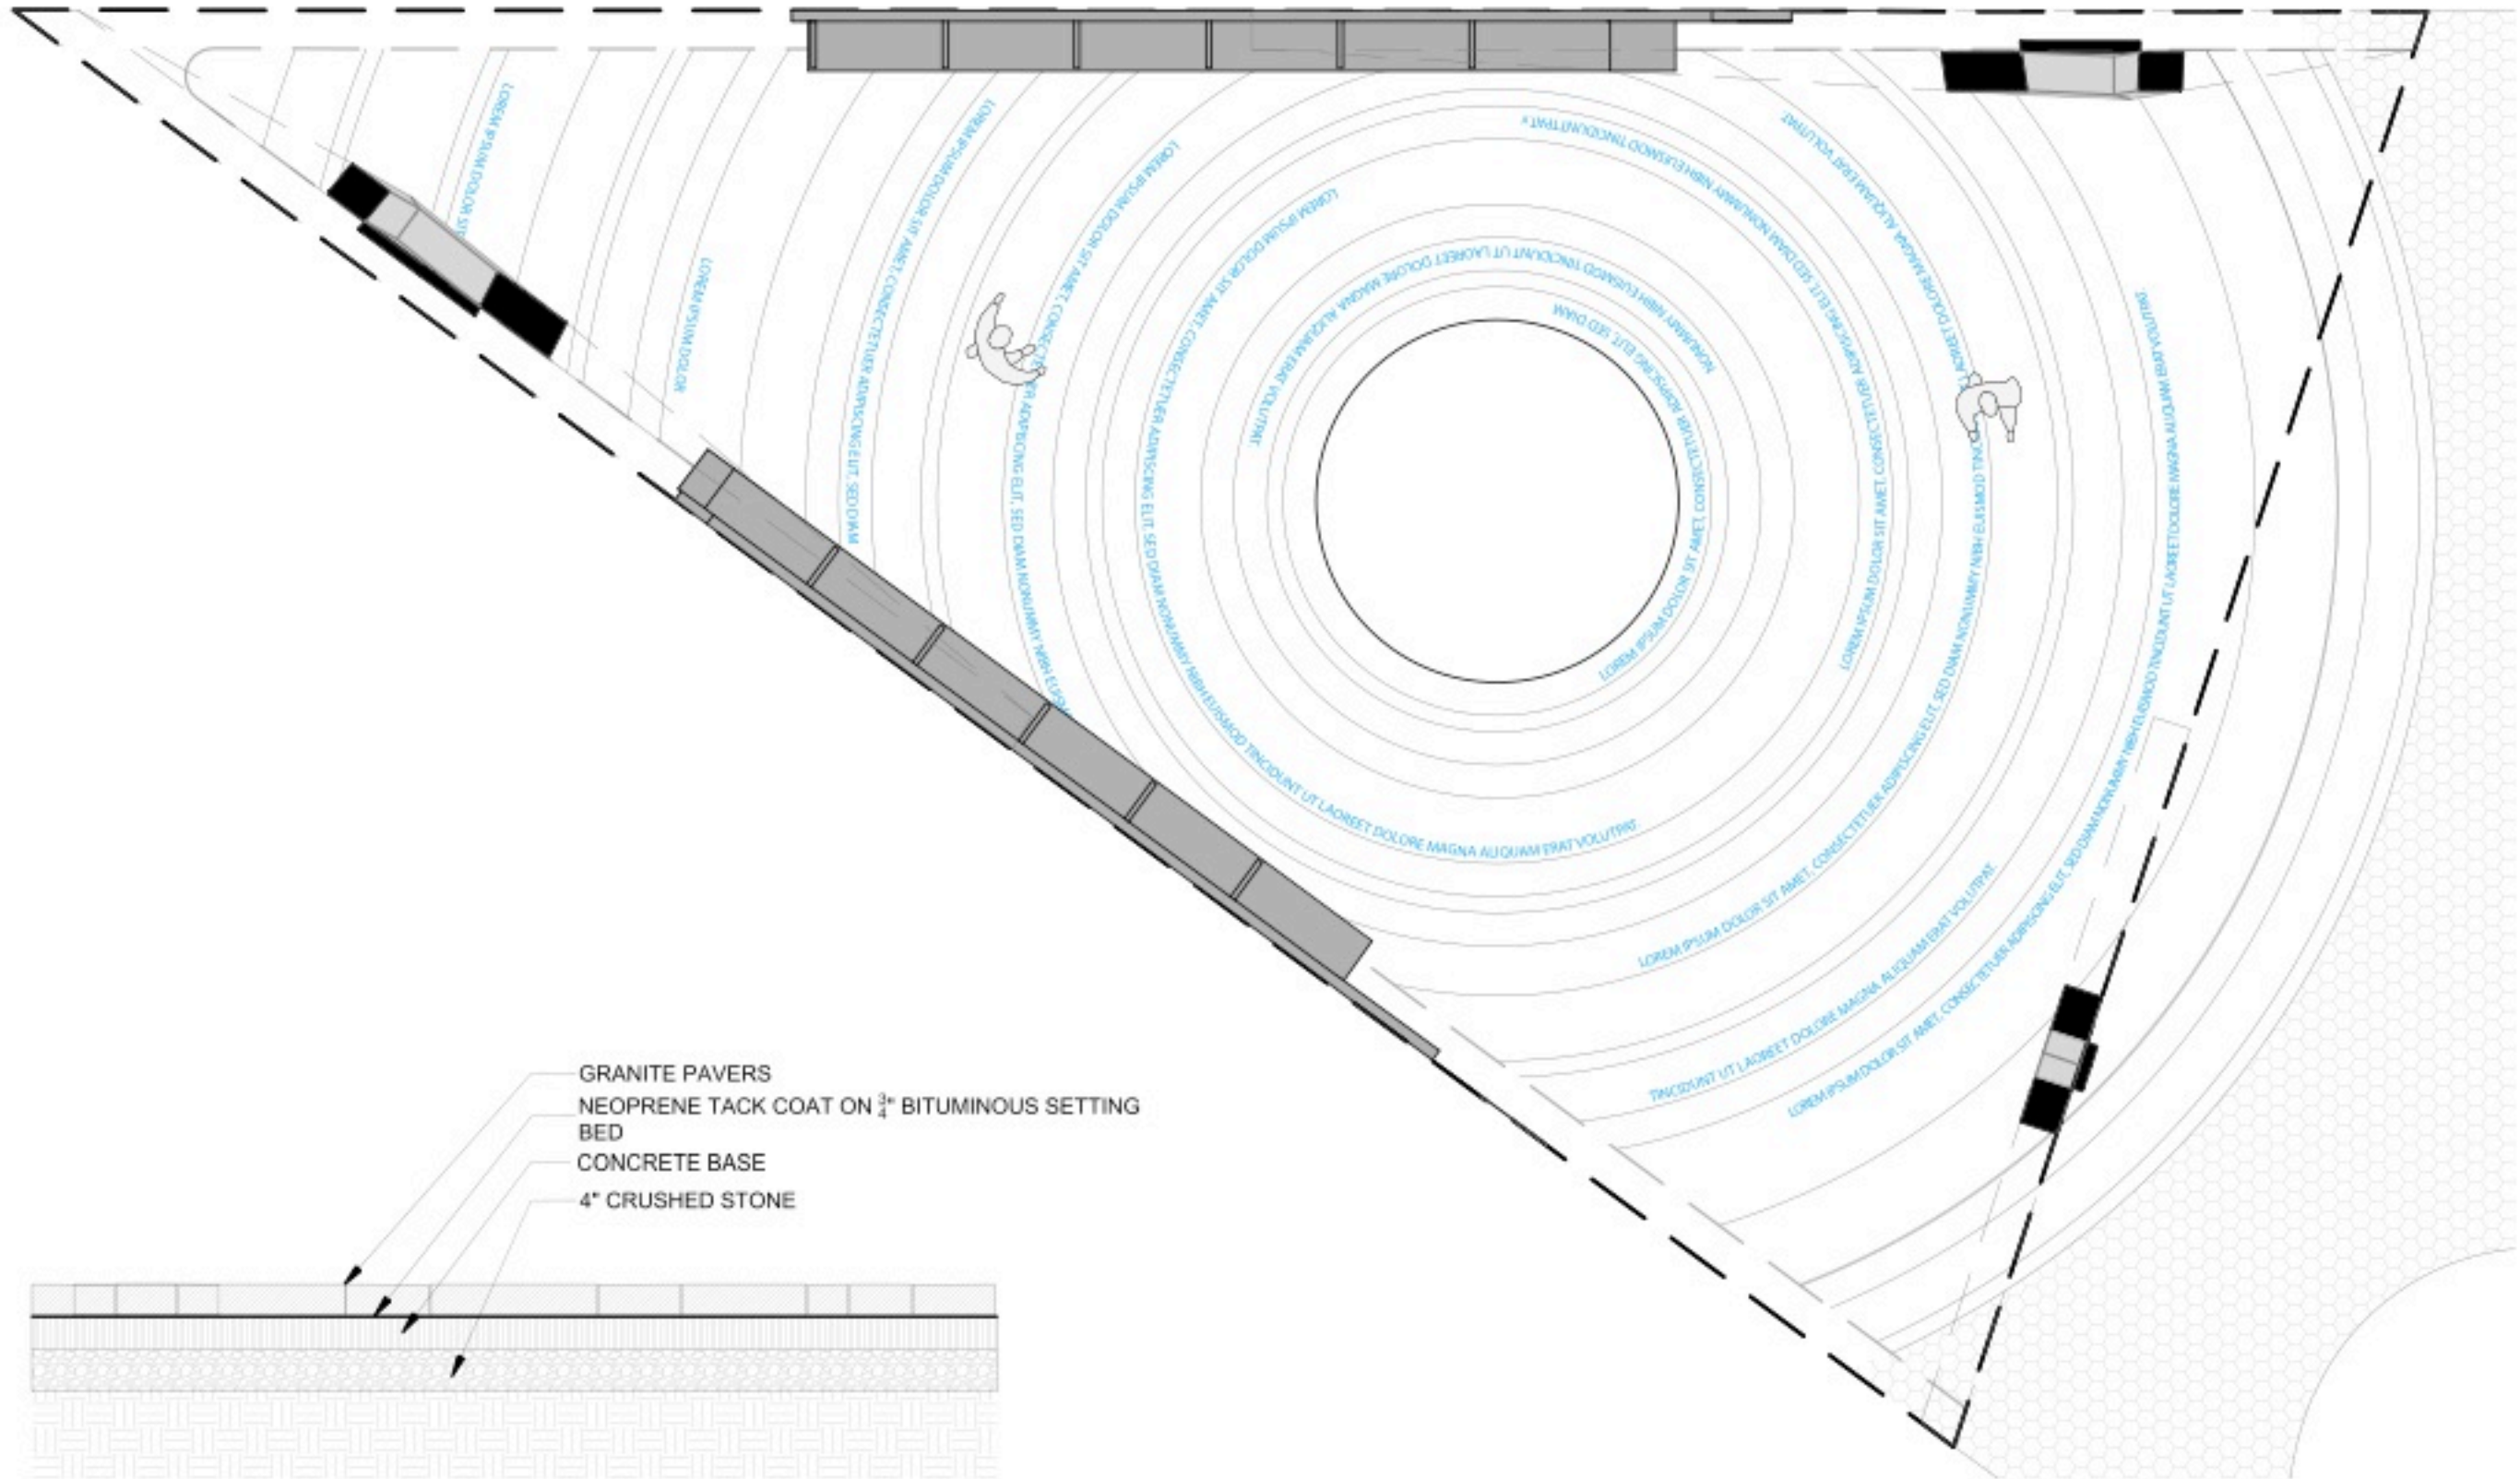


THE MEMORIAL LIGHTING

Annotated lighting plan

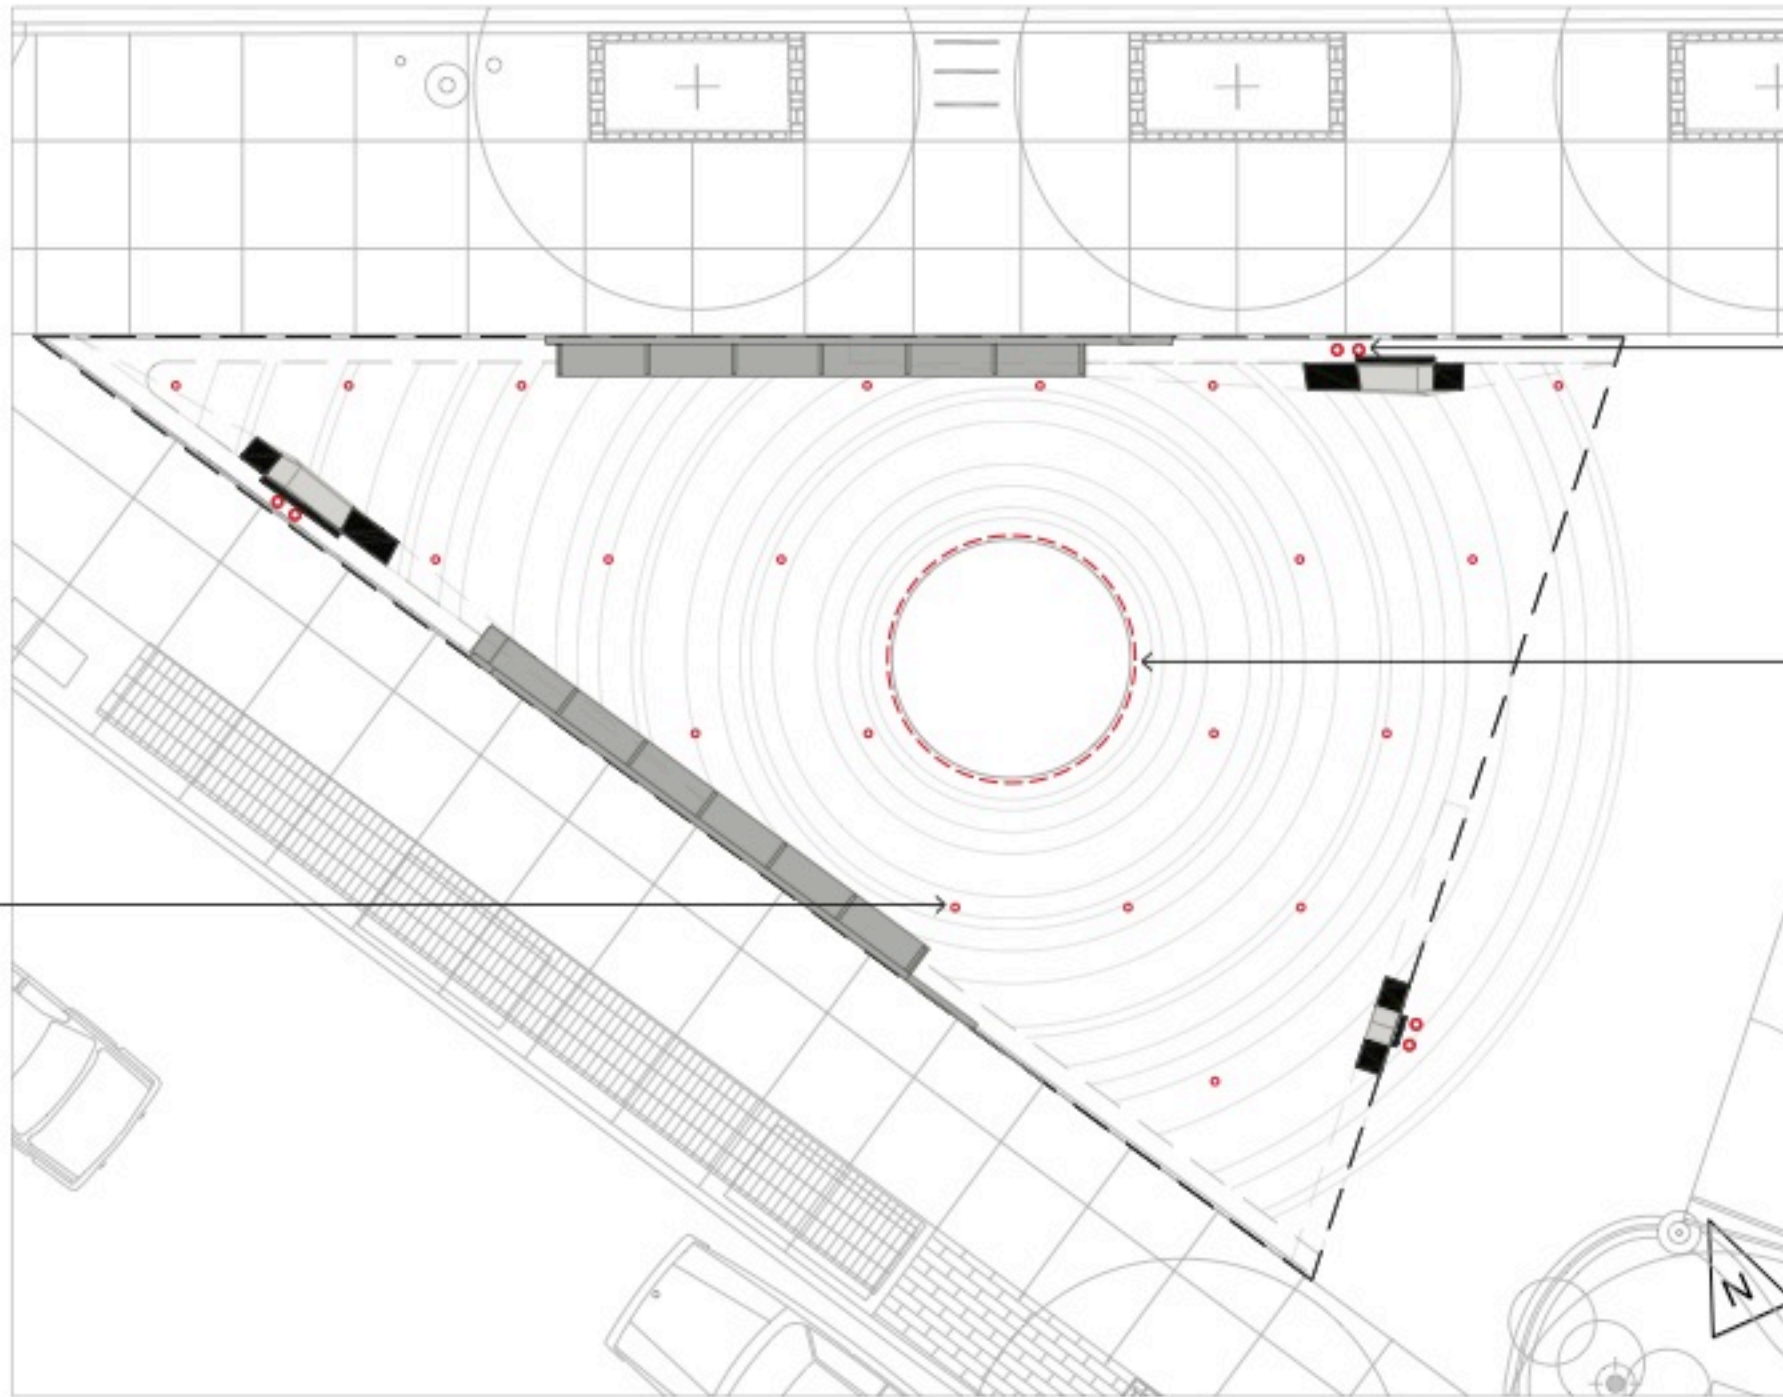

SITE LIGHTING LAYOUT

Miniature downlights
concealed within canopy,
aligned with paving
pattern.

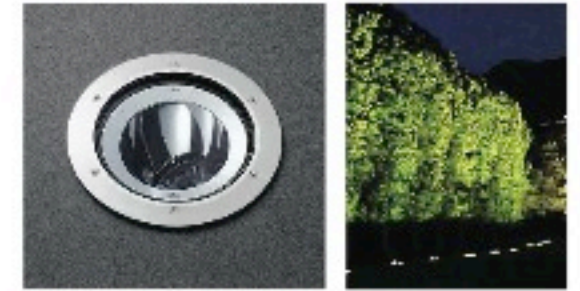

In-grade fixture to uplight planted
vertical surface.

Linear fixture at perimeter of water
feature.






STRUCTURAL STEEL

COLOR: Benjamin Moore Kendal Charcoal

FINISH: Zinc Carboline primer / Epoxy Paint / Polyurethane top-coat

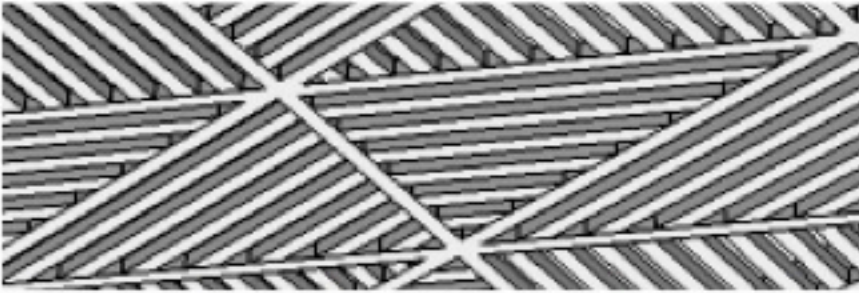

SLATS

MATERIAL: 4" x 4" Painted steel tube

COLOR: Benjamin Moore Galveston Gray

FINISH: Zinc Carboline primer / Epoxy Paint / Polyurethane top-coat



GRANITE

COLOR: Charcoal Black™, CPREVIOUS Spring Granite, MN

FINISH: Rub & Sand




STAINLESS STEEL

COLOR: natural color

FINISH: brushed

APPLICATIONS: bollards and bench arm rest

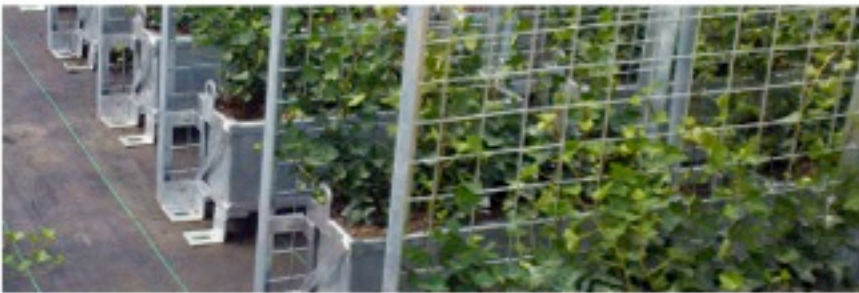


PLANTERS

QUANTITY: x24 (5' long x 12" wide x 14" deep)

- Double wall insulated fiberglass planter
- Irrigation dripline 17mm pipes, 6" spacing

COLOR: Benjamin Moore Galveston Gray (to match slat color)

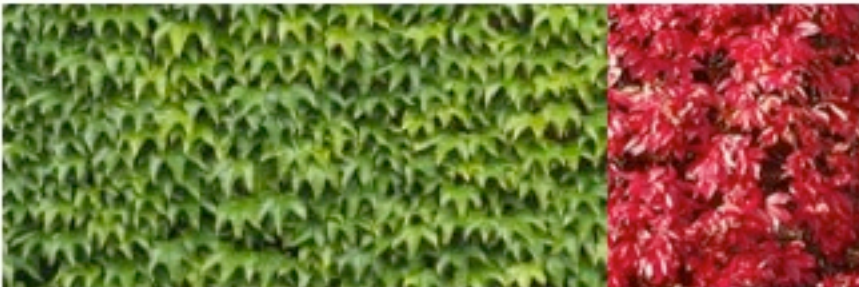

PLANT SELECTION


- English Ivy: 18 planters (70%) – EVERGREEN VINE
- Virginia Creeper: 6 planters (30%) – PERENNIAL VINE seasonal



STRUCTURAL STEEL

COLOR: Benjamin Moore Kendal Charcoal

FINISH: Zinc Carboline primer / Epoxy Paint / Polyurethane top-coat

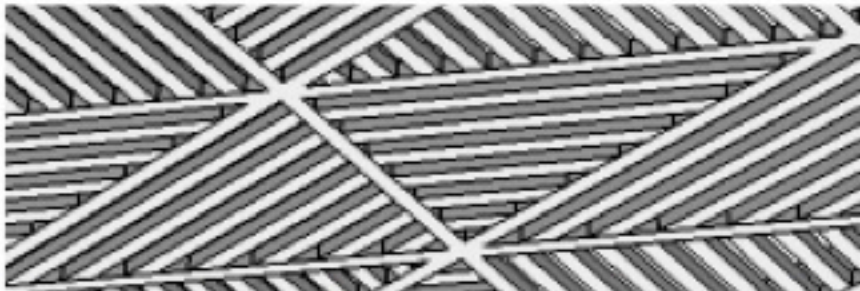

SLATS

MATERIAL: 1" x 3" Painted solid steel plates

COLOR: Benjamin Moore Galveston Gray

FINISH: Zinc Carboline primer / Epoxy Paint / Polyurethane top-coat



GRANITE

COLOR: Charcoal Black™, CPREVIOUS Spring Granite, MN

FINISH: Rub & Sand



STAINLESS STEEL

COLOR: natural color

FINISH: brushed

APPLICATIONS: bench arm rest